

**CITY OF BATON ROUGE
PARISH OF EAST BATON ROUGE
DEPARTMENT OF ENVIRONMENTAL SERVICES**

October 27, 2025

ADDENDUM NO. 2R

TO: ALL BIDDERS

SUBJECT: **PS 299 REGIONAL PUMP STATION**

CITY-PARISH PROJECT NO. 20-PS-IF-0109R

The following revisions shall be incorporated in and take precedence over any conflicting part of the original contract document:

ORIGINAL BID DATE: Thursday, October 23, 2025 at 2:00 P.M.

CURRENT BID DATE: Thursday, October 30, 2025 at 2:00 P.M.

PART 1 – UNIFORM CONSTRUCTION BID FORMS:

1. For paper sealed bidders, with reference to page UCBF 1 of 4 of Part 1, Uniform Construction Bid Forms, the Bidder shall indicate the receipt of this addendum in the space provided. For online Central Bidding bidders, an acknowledgement of this addendum will be prompted by the electronic bidding program prior to formally submitting the bid. **Failure to indicate the receipt of this addendum shall be cause for the bid to be rejected.**

PART 2 – SPECIAL PROVISIONS AND CONTRACT DOCUMENTS:

1. For paper sealed bidders, with reference to page UCBF 1 of 4 of Part 1, Uniform Construction Bid Forms, the Bidder shall indicate the receipt of this addendum in the space provided. For online Central Bidding bidders, an acknowledgement of this addendum will be prompted by the electronic bidding program prior to formally submitting the bid. **Failure to indicate the receipt of this addendum shall be cause for the bid to be rejected.**

DRAWINGS

1. Sheet C-4R: Remove this sheet in its entirety and replaced with the revised version attached to this addendum (revision dated 10/27/25 for Addendum 2R).
2. Sheet C-18R: Remove this sheet in its entirety and replaced with the revised version attached to this addendum (revision dated 10/27/25 for Addendum 2R).
3. Sheet C-19R: Remove this sheet in its entirety and replaced with the revised version attached to this addendum (revision dated 10/27/25 for Addendum 2R)

4. Sheet C-20R: Remove this sheet in its entirety and replaced with the revised version attached to this addendum (revision dated 10/27/25 for Addendum 2R).
5. Sheet C-21R: Remove this sheet in its entirety and replaced with the revised version attached to this addendum (revision dated 10/27/25 for Addendum 2R).

QUESTIONS:

1. Specification section 01 14 00, paragraph 1.07 (E) states "The Constantin Blvd. WW FM and gravity sewer system shall be completed and operational before the new PS 299 can become operational." What is the current status of the Constantin Blvd. project?

The gravity sewer and force main along Constantin Blvd are still under construction but are scheduled to be finished before the PS 299 tie-in and start up.

2. Please confirm that the PS 299 contractor will have access to the construction site through the current Constantin Blvd project.

The Contractor will not have access to the project from the current Constantin Blvd project.

3. Does the schedule have to be cost loaded?

The schedule does not have to be cost loaded, but a schedule of values will be required as per the Specifications.

 
4. Please confirm we can still deviate from the 1' thickness as this thickness is only for 120" and larger manholes.

The Contractor may deviate from the specified thickness, but is required to provide signed structural calculations, included buoyancy calculations as required by the note.

5. Addendum 1 revised the lengths of both gravity sewers and force mains. The revised lengths now appear to include the portions of pipe that are noted on the plan and profile drawings to be included with the pump station. Please clarify if the stations provided in the general notes on the plan and profile drawings are to be followed, or if all pipe is now measured and paid under the individual items.

The stationing provided in the general notes on the plan and profile drawings are now updated. The below ground piping shown on the plan and profile drawings are to be measured and paid for under individual items. The piping in the wet well and all above ground piping is included in the Pump Station.

REVIEWED:




Sparkle D.W. Noble, P.E.



Obie E. Watts, III, P.E.

 
APPROVED:




Adam M. Smith, P.E.



1 EX. PS299
NO SCALE

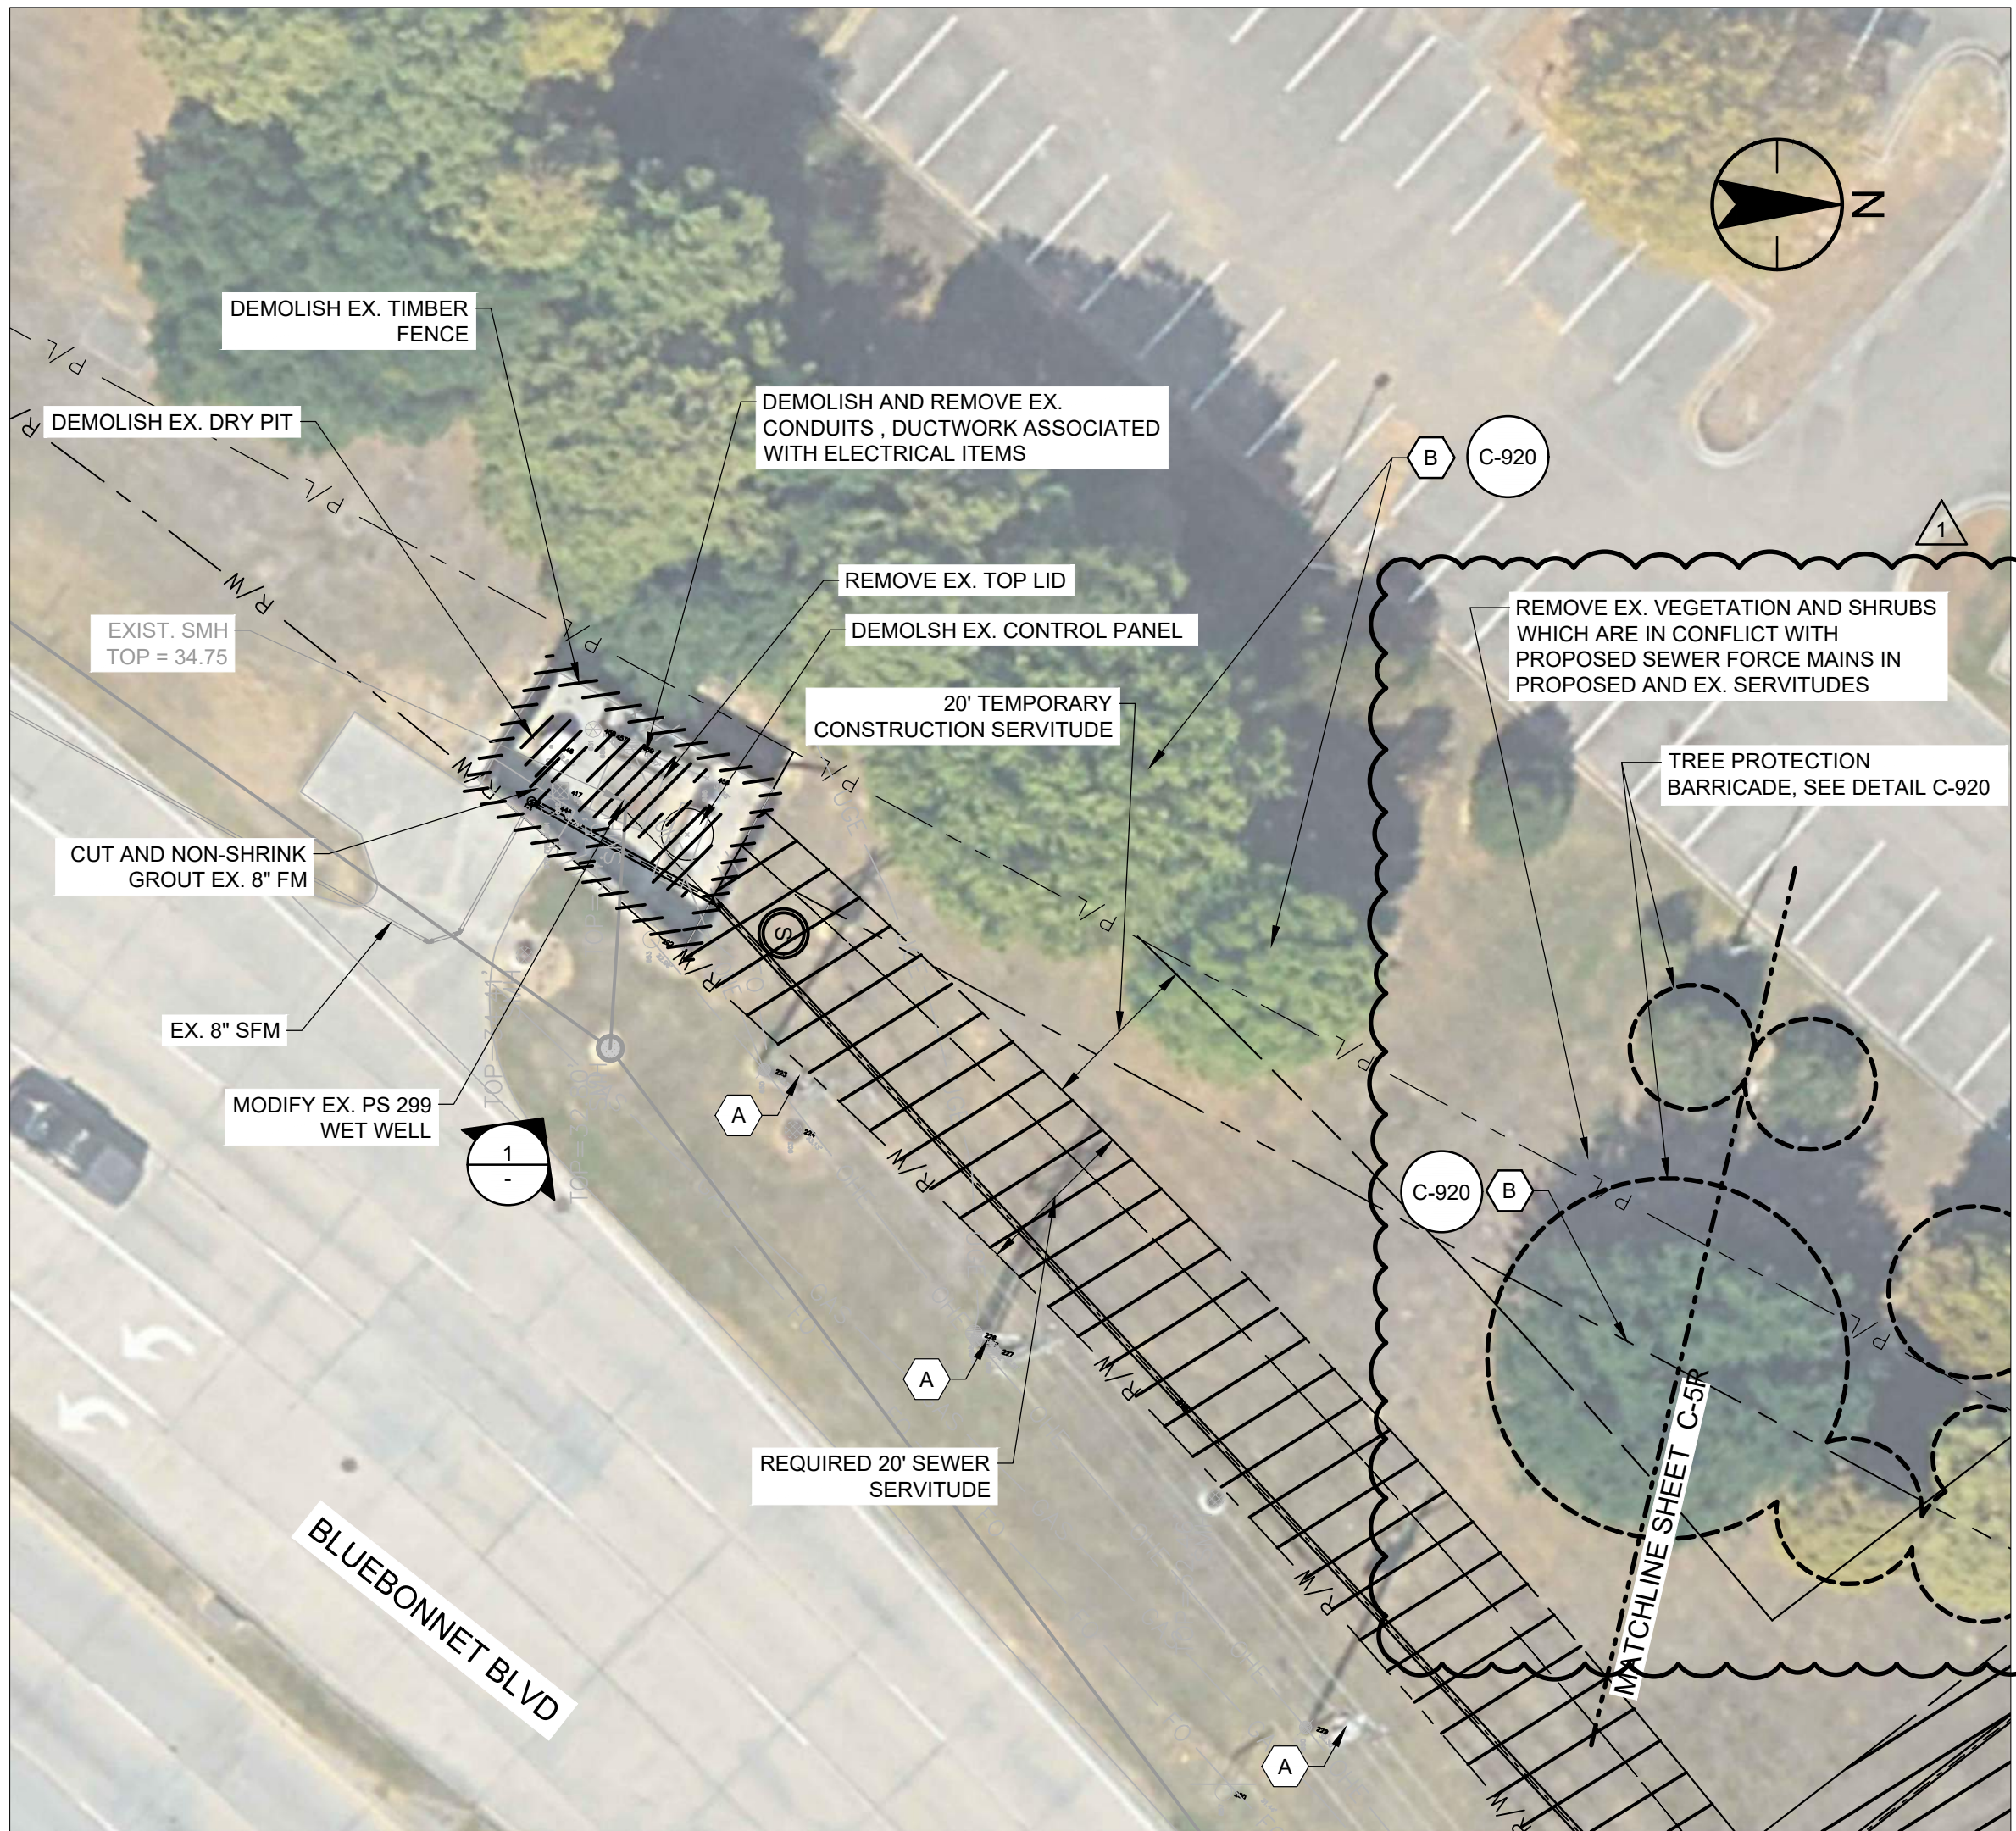

PLAN
SCALE 1" = 20'

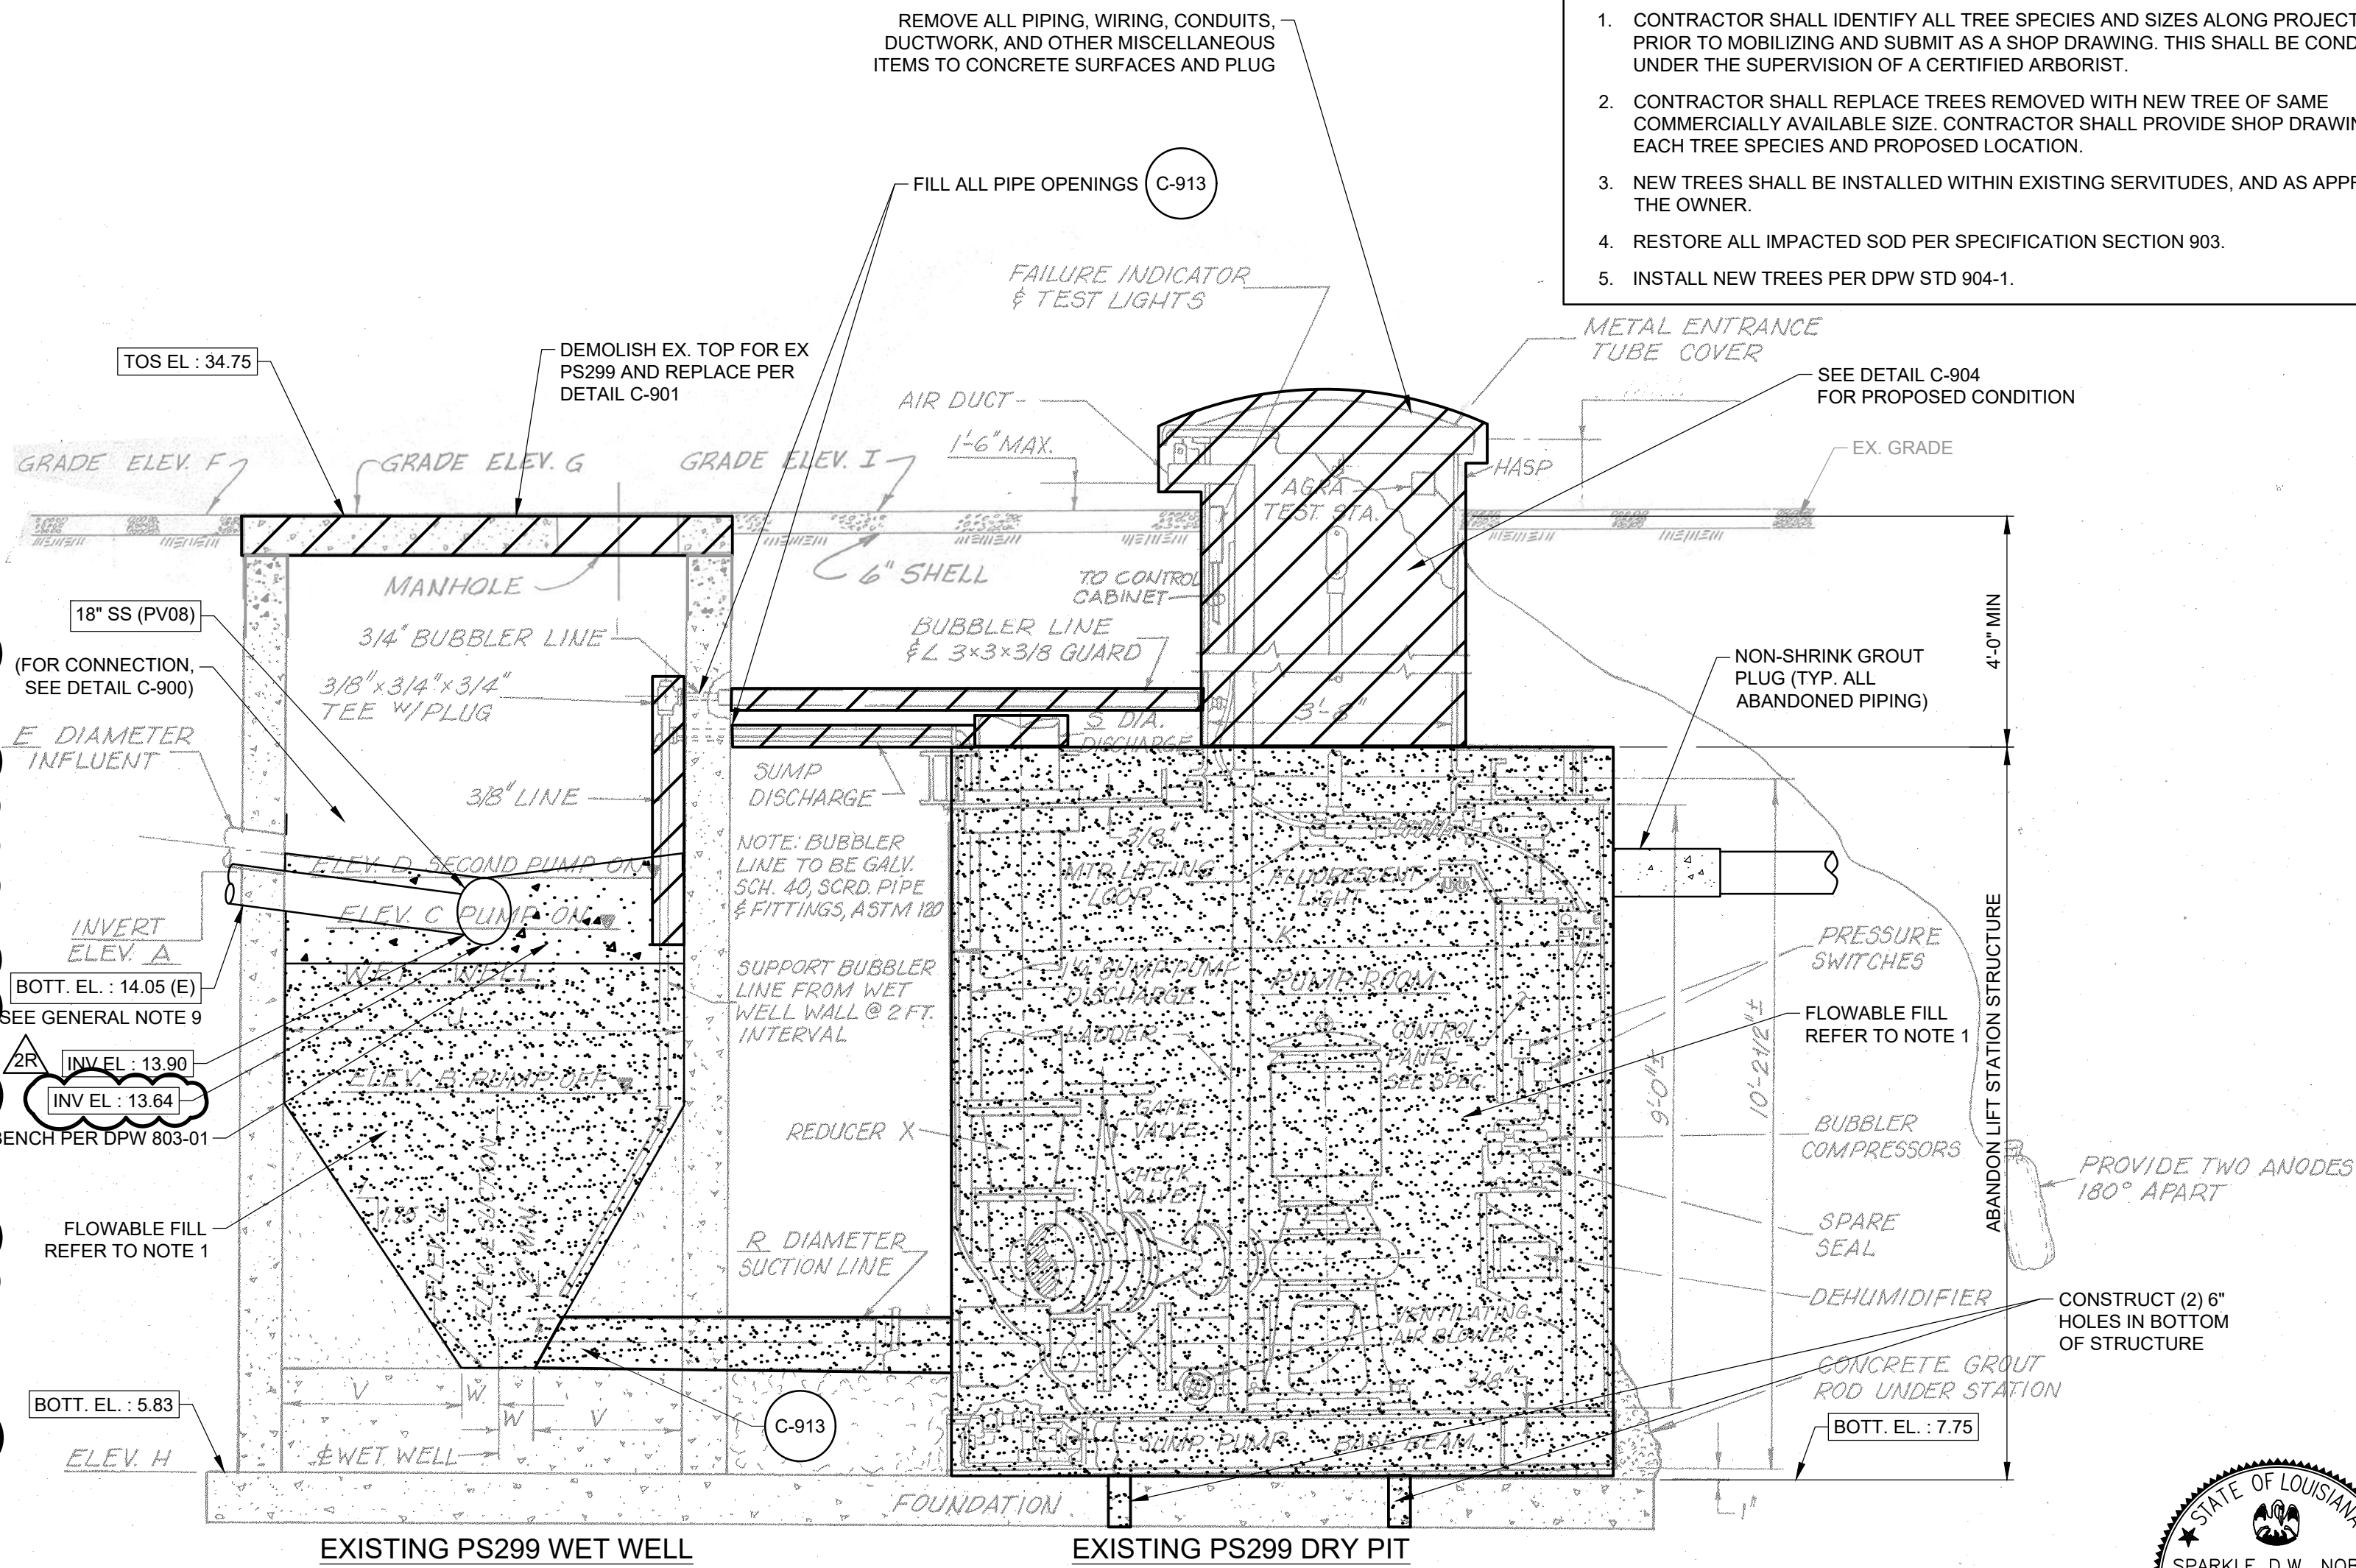

A	B	C	D	E	F	G	H	I	J	K	L	M	N	O	P	Q	R	S	T	U	V	W	X
14.05	10.05	13.05	14.05	16"	34.75	34.75	7.09	34.75	6'-0"	8'-0"	3'-6"	10'-6"	5'-9"	5'-0"	2'-0"	5'-9"	8"	8"	9.88	9.55	2'-0"	1'-0"	8x4

EX. PS299 SECTION
NO SCALE

SHEET KEYNOTES

- EX. UTILITY POLE TO BE BRACED AND PROTECTED THROUGHOUT CONSTRUCTION. SEE SPECIFICATIONS.
- PROTECT EX. TREE.

LEGEND

- | | |
|--|--|
| | FLOWABLE FILL (SEE SPECIFICATION SECTION 911, VOLUME II) |
| | DEMOLITION EXTENTS |
| | BEDDING BACKFILL |

KEY PLAN



GENERAL SHEET NOTES

- THE CONTRACTOR SHALL DEMOLISH THE EX. PUMP STATION WET WELL LID AND PUMP ROOM TO 4' BELOW EX. GRADE. ALL PUMPS, VALVES, AND PIPING SHALL BE REMOVED PRIOR TO BACKFILL OPERATIONS. ALL PIPING BETWEEN THE STRUCTURES AT A DEPTH GREATER THAN 4' SHALL BE GROUTED IN WITH FLOWABLE FILL. BOTH THE WET WELL AND PUMP ROOM SHALL BE PROPERLY CLEANED. SEE SPECIFICATION SECTION 812.
- (2) 6" DIAMETER HOLES SHALL BE DRILLED INTO THE BOTTOM OF THE WET WELL AND DRY PIT MANHOLE AND PUMP STATION WET WELL STRUCTURE PRIOR TO BACKFILLING WITH SAND FOR EX. PUMP STATION 299.
- THE CONTRACTOR SHALL INSTALL A NEW TOP SLAB AND WET WELL LID FOR PUMP STATION 299 WET WELL.
- OWNER RESERVES THE RIGHT TO SALVAGE EQUIPMENT AND CONTRACTOR IS RESPONSIBLE FOR COORDINATING THIS WITH THE OWNER. ALL DEBRIS AND EQUIPMENT NOT SALVAGED BY THE OWNER WILL BE THE PROPERTY OF THE CONTRACTOR AND REMOVED FROM THE PROJECT SITE UNLESS OTHERWISE INDICATED.
- CONTRACTOR SHALL COORDINATE POWER DEMOLITIONS WITH ENTERGY.
- CONTRACTOR SHALL PROVIDE TEMPORARY LIGHTING AS REQUIRED. SEE SPECIFICATION 01 51 00 FOR ADDITIONAL REQUIREMENTS.
- ALL ELEVATIONS SHOWN HEREIN ARE IN FEET AND REFER TO THE NAVD 1988 DATUM.
- SEE SPECIFICATION SECTION 821 FOR ADDITIONAL REQUIREMENTS.
- CONTRACTOR SHALL PROVIDE SURVEYED ELEVATION OF EX. 299 WET WELL PRIOR TO SUBMITTAL OF GRAVITY SEWER SHOP DRAWINGS.
- WORK ASSOCIATED WITH THE DEMOLITION OF EXISTING PS 299 WILL BE PAID FOR UNDER PAYITEM DEMOLITION & RESTORATION OF PUMP STATION (PS NO. 299).

LANDSCAPE NOTES

- CONTRACTOR SHALL IDENTIFY ALL TREE SPECIES AND SIZES ALONG PROJECT LIMITS PRIOR TO MOBILIZING AND SUBMIT AS A SHOP DRAWING. THIS SHALL BE CONDUCTED UNDER THE SUPERVISION OF A CERTIFIED ARBORIST.
- CONTRACTOR SHALL REPLACE TREES REMOVED WITH NEW TREE OF SAME COMMERCIALY AVAILABLE SIZE. CONTRACTOR SHALL PROVIDE SHOP DRAWING OF EACH TREE SPECIES AND PROPOSED LOCATION.
- NEW TREES SHALL BE INSTALLED WITHIN EXISTING SERVITUDES, AND AS APPROVED BY THE OWNER.
- RESTORE ALL IMPACTED SOD PER SPECIFICATION SECTION 903.
- INSTALL NEW TREES PER DPW STD 904-1.

SHEET NUMBER				12			
				DESIGNED LH	PARISH	EAST BATON ROUGE	
				CHECKED GB	CITY PROJECT	20-PS-IF-0109	
				DATE	STATE PROJECT	H.012232	
				10/18/2024			
				12 OF 101			




CIVIL
DEMOLITION PLAN- I
PS299 REGIONAL PUMP STATION





C-4R

c:\pwworking\vip\kch\h\0201976\02937-c-13_c-14
2025.10.27 10:51:44 AM

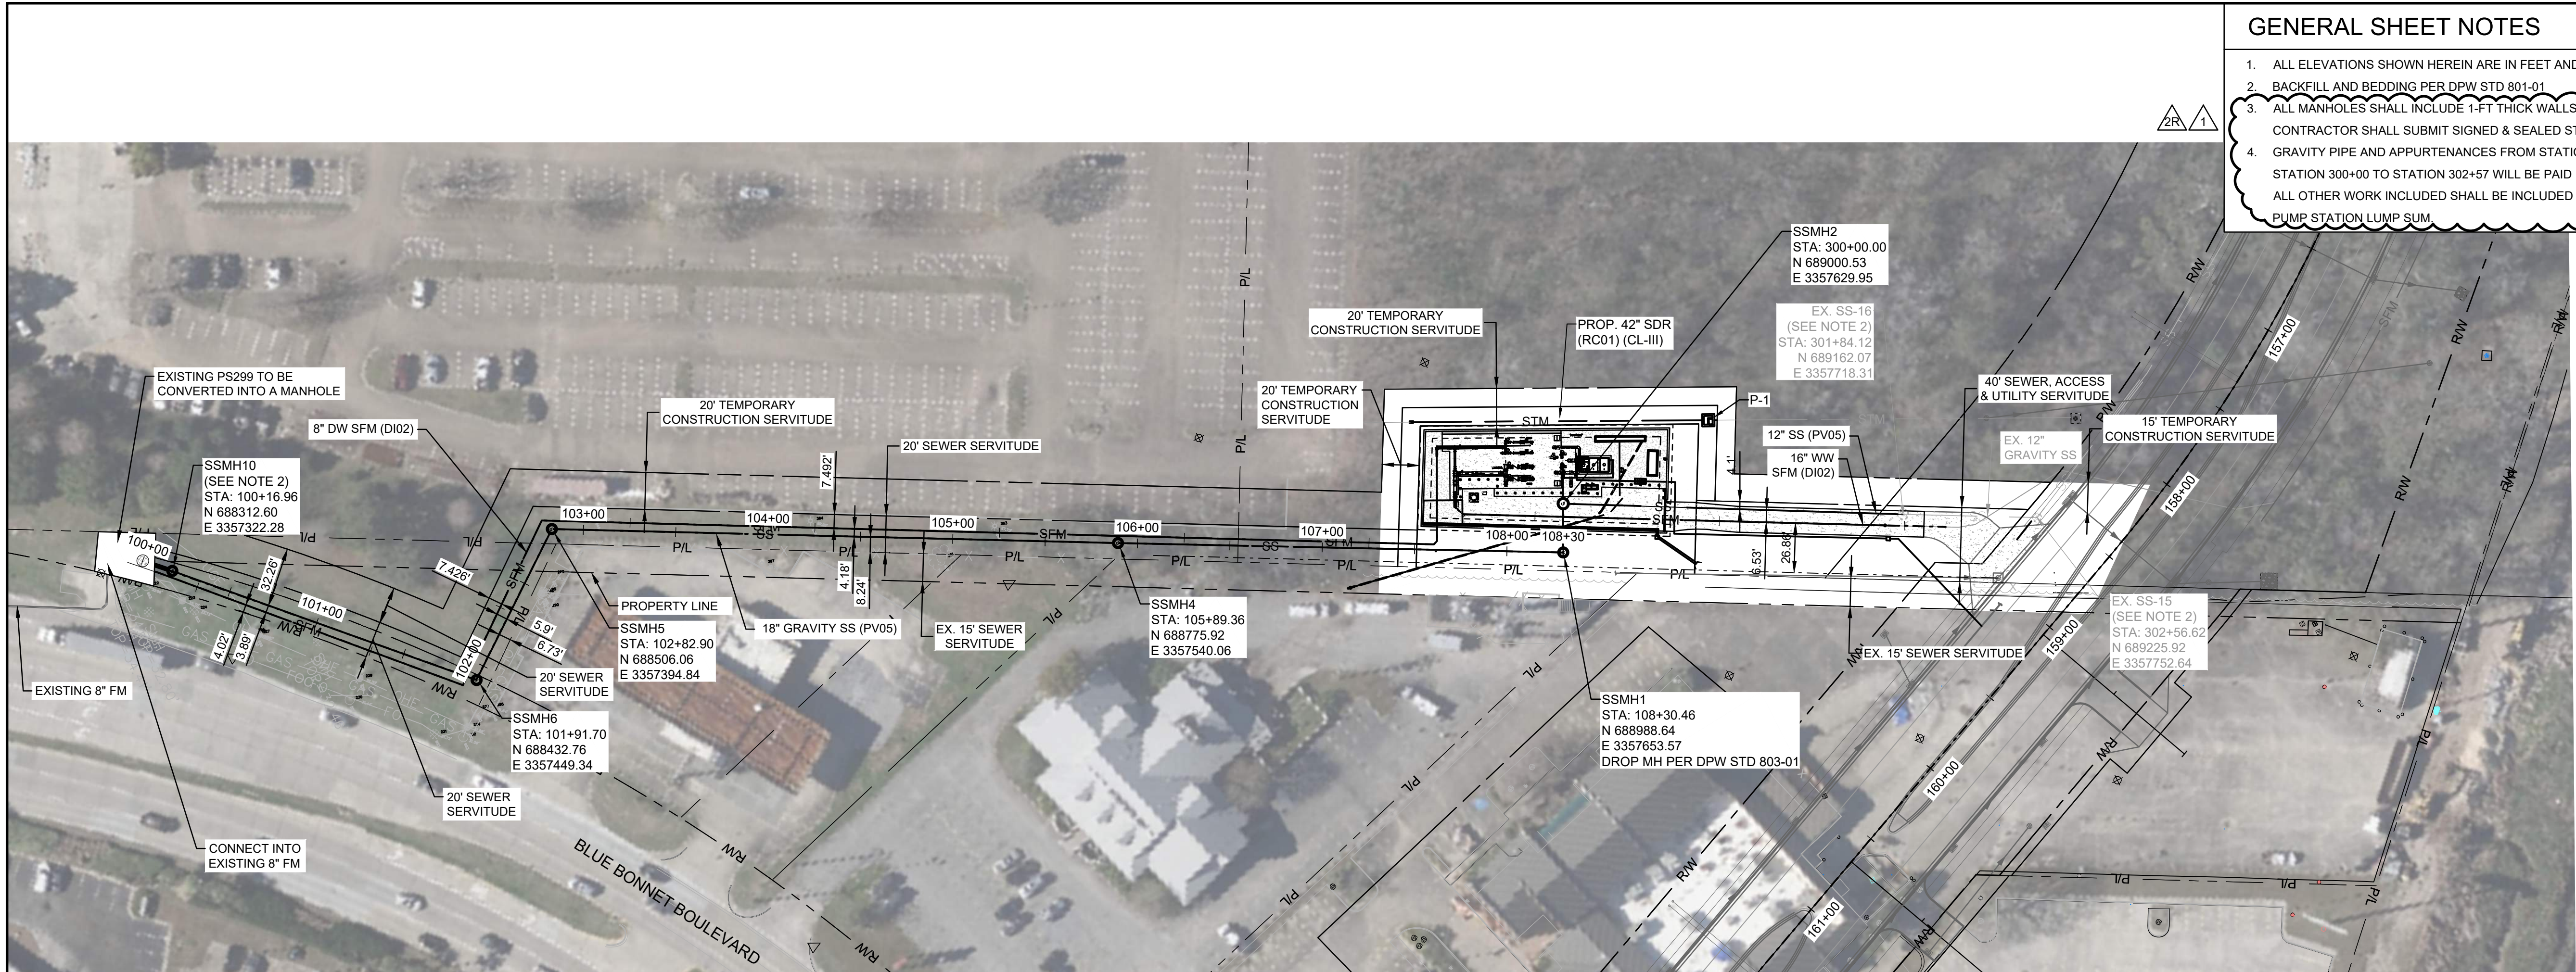

PLAN

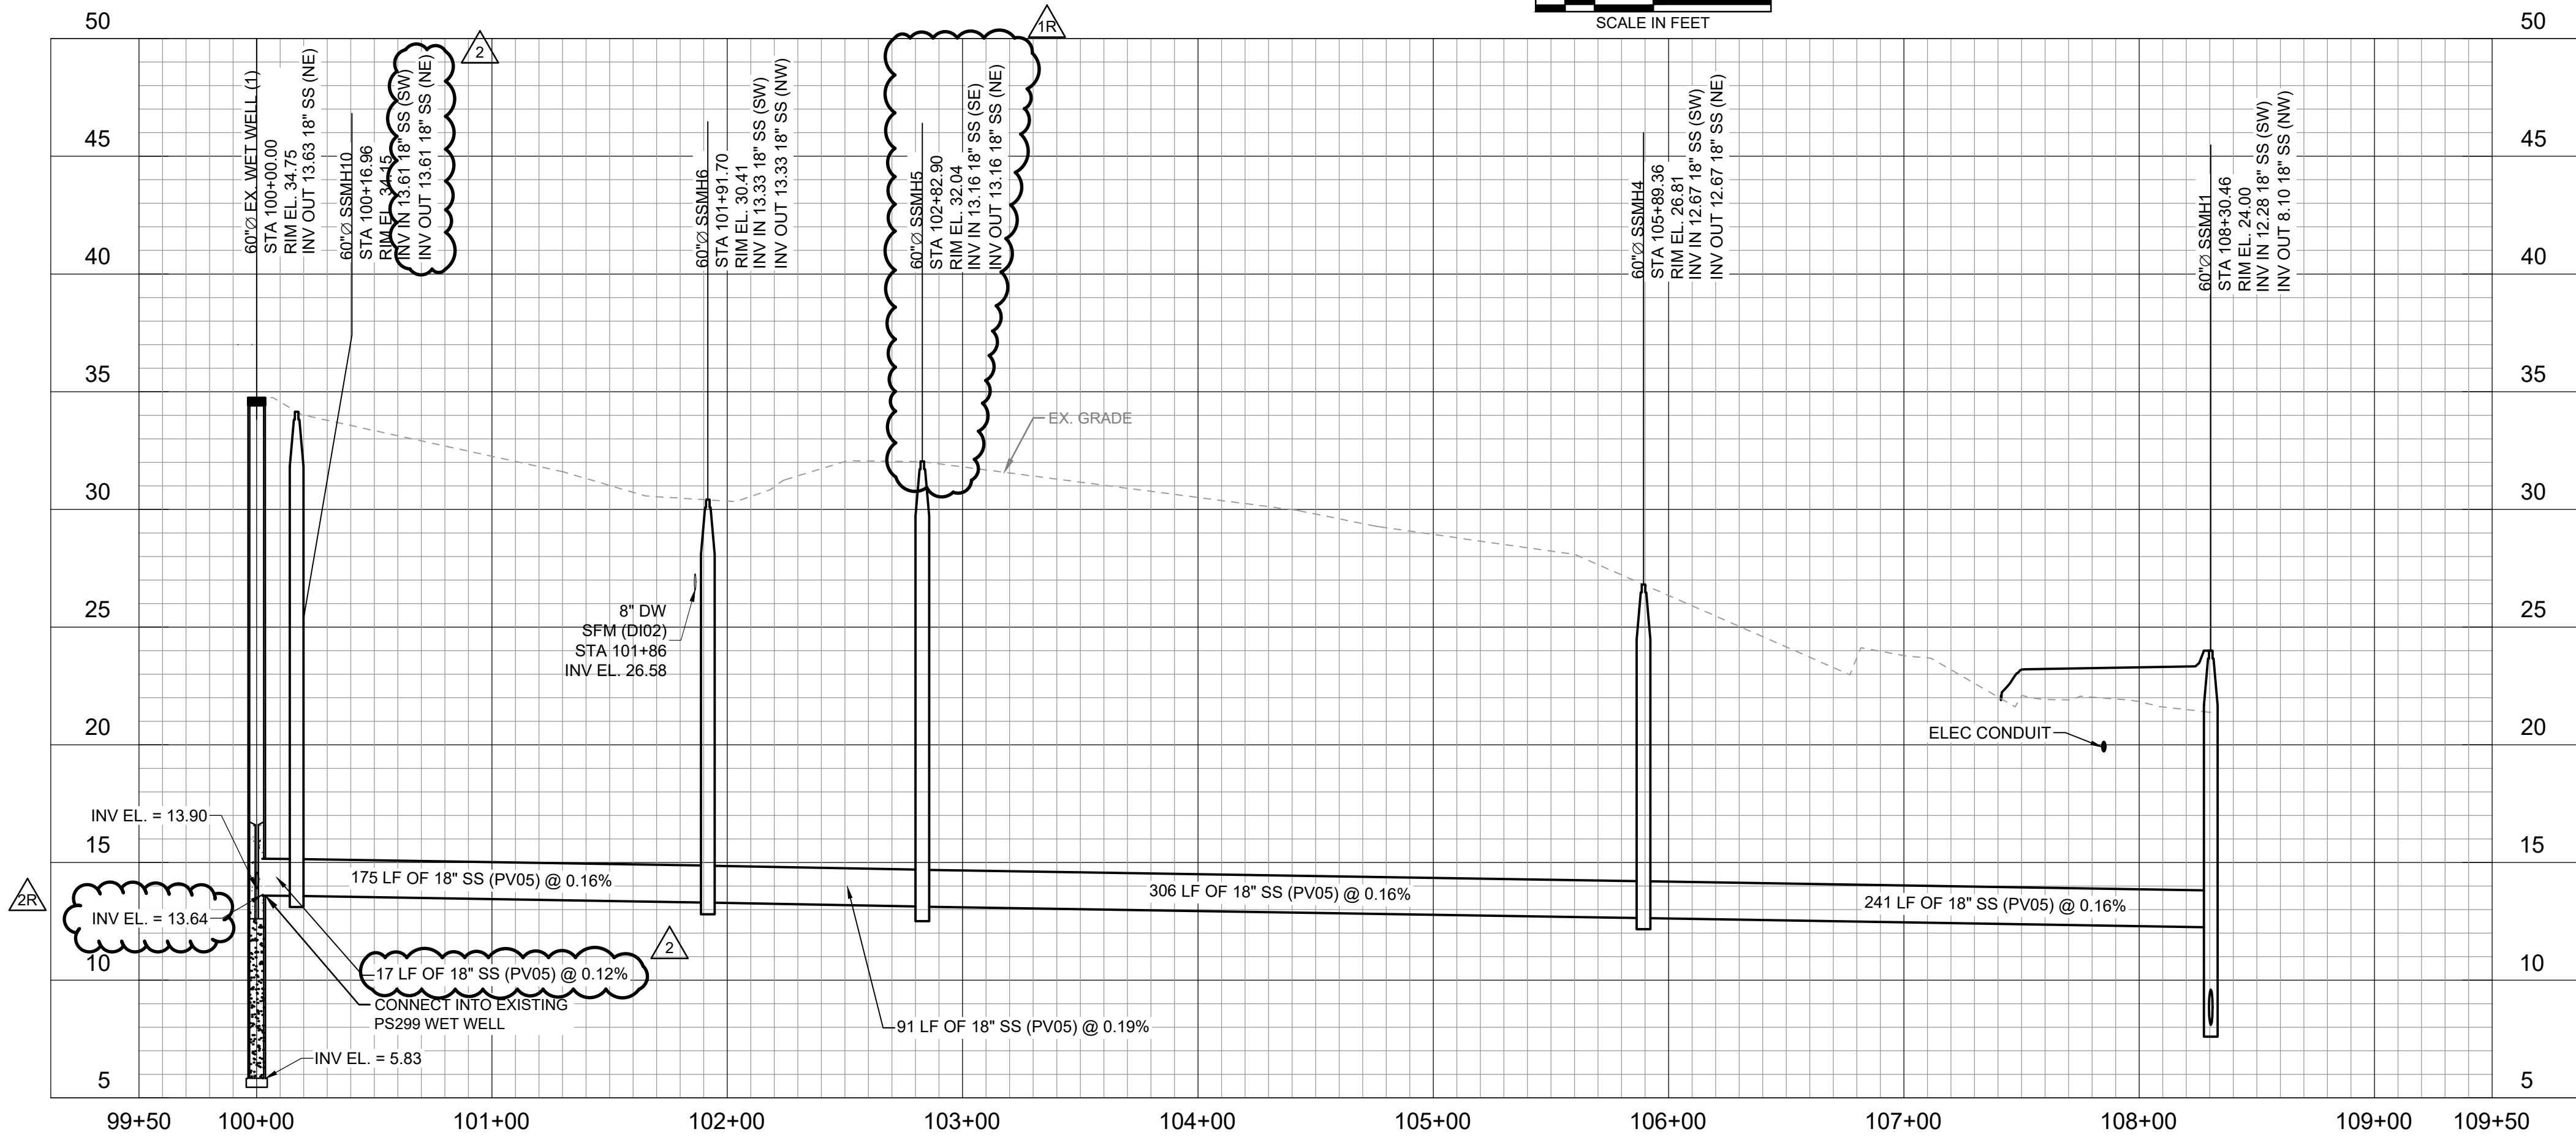 

PROFILE

HORIZ SCALE: 1"=50'
VERT SCALE: 1"=5'

GENERAL SHEET NOTES

1. ALL ELEVATIONS SHOWN HEREIN ARE IN FEET AND REFER TO THE NAVD 1988 DATUM.
2. BACKFILL AND BEDDING PER DPW STD 801-01
3. ALL MANHOLES SHALL INCLUDE 1-FT THICK WALLS, BOTTOM SLABS, AND TOP SLABS. CONTRACTOR SHALL SUBMIT SIGNED & SEALED STRUCTURAL CALCULATIONS.
4. GRAVITY PIPE AND APPURTENANCES FROM STATION 100+00.00 TO STATION 108+30.46 AND STATION 300+00 TO STATION 302+57 WILL BE PAID FOR WITH ASSOCIATED UNIT PRICES. ALL OTHER WORK INCLUDED SHALL BE INCLUDED IN THE PRICE SUBMITTED FOR THE PUMP STATION LUMP SUM.

SHEET NUMBER		26	
EAST BATON ROUGE		PARISH	
DESIGNED CHECKED	LH GB		
20-PS-IF-0109		QTY PROJECT	
DETAILED CHECKED	MM SN		
10/18/2024		DATE SHEET	10/18/2024 26 OF 101
H.012232		STATE PROJECT	
ADDENDUM NO. 2R		BY	
ADDENDUM NO. 1R	10/27/2025		
ADDENDUM NO. 2	10/17/2025		
ADDENDUM NO. 1	11/18/2024		
ADDENDUM NO. 1	11/05/2024		
ISSUED FOR BID	0	DATE	10/18/2024
REVISION DESCRIPTION	0		




CIVIL
SEWER PLAN AND PROFILE -- 1


PS299 REGIONAL PUMP STATION





C-18R

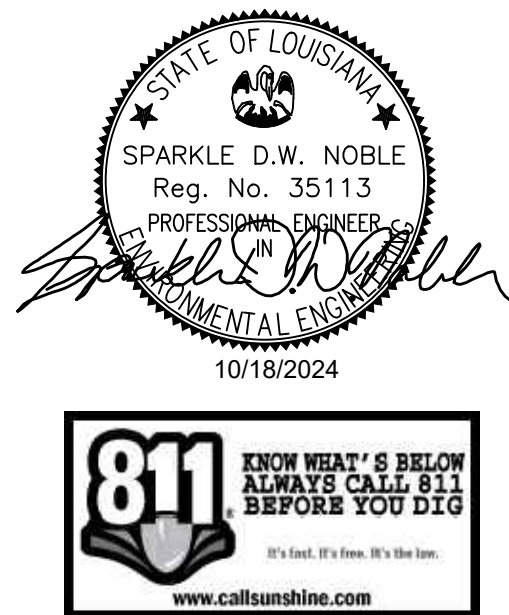



c:\pwworking\vip\kch\h\0201976-02937-c-13_c-16
2025.10.27 10:50:14 AM

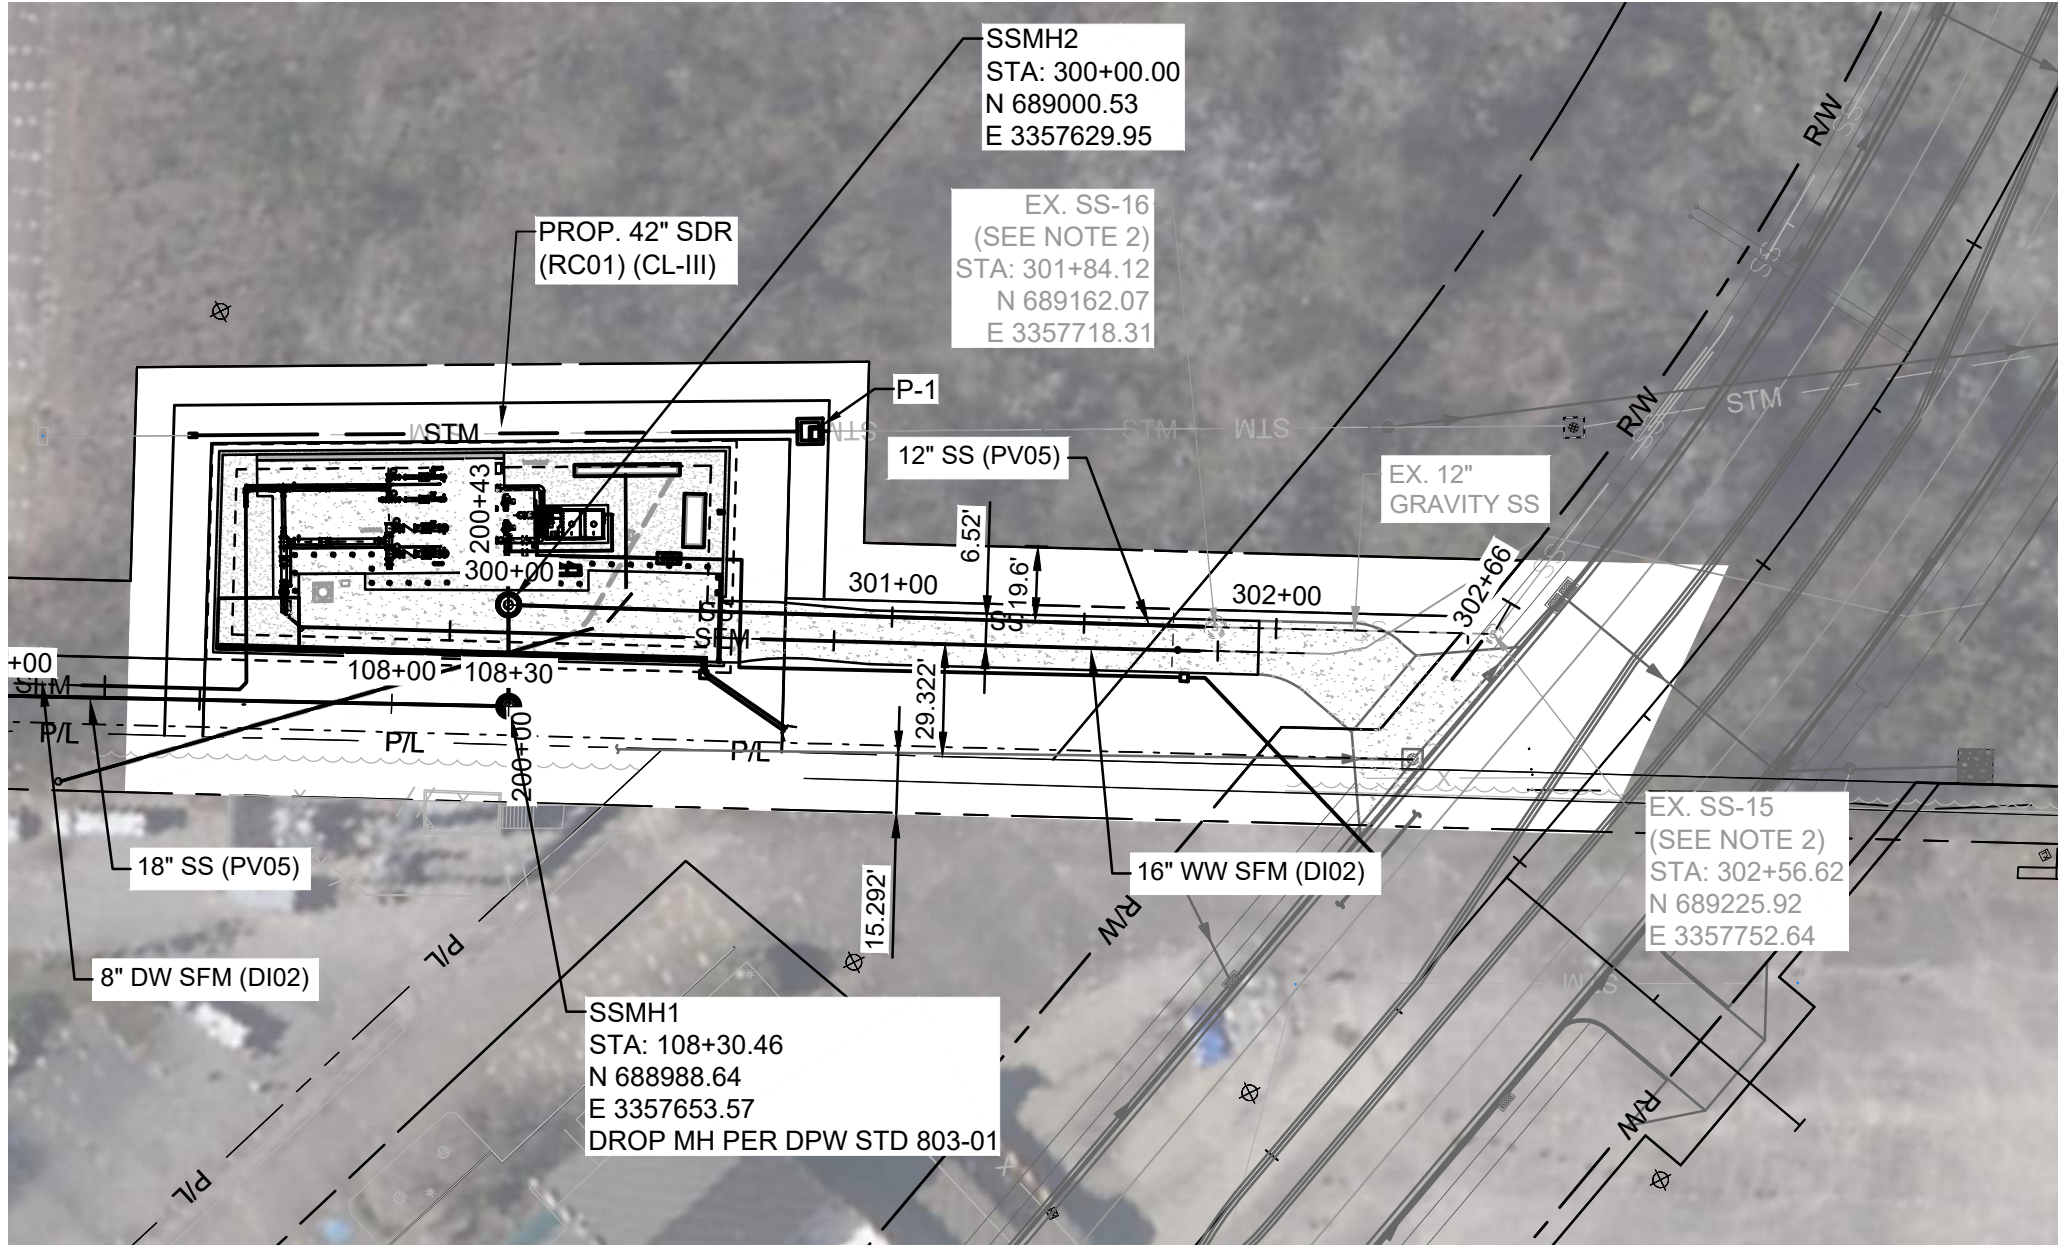

SSMH2 TO SSMH3 PLAN

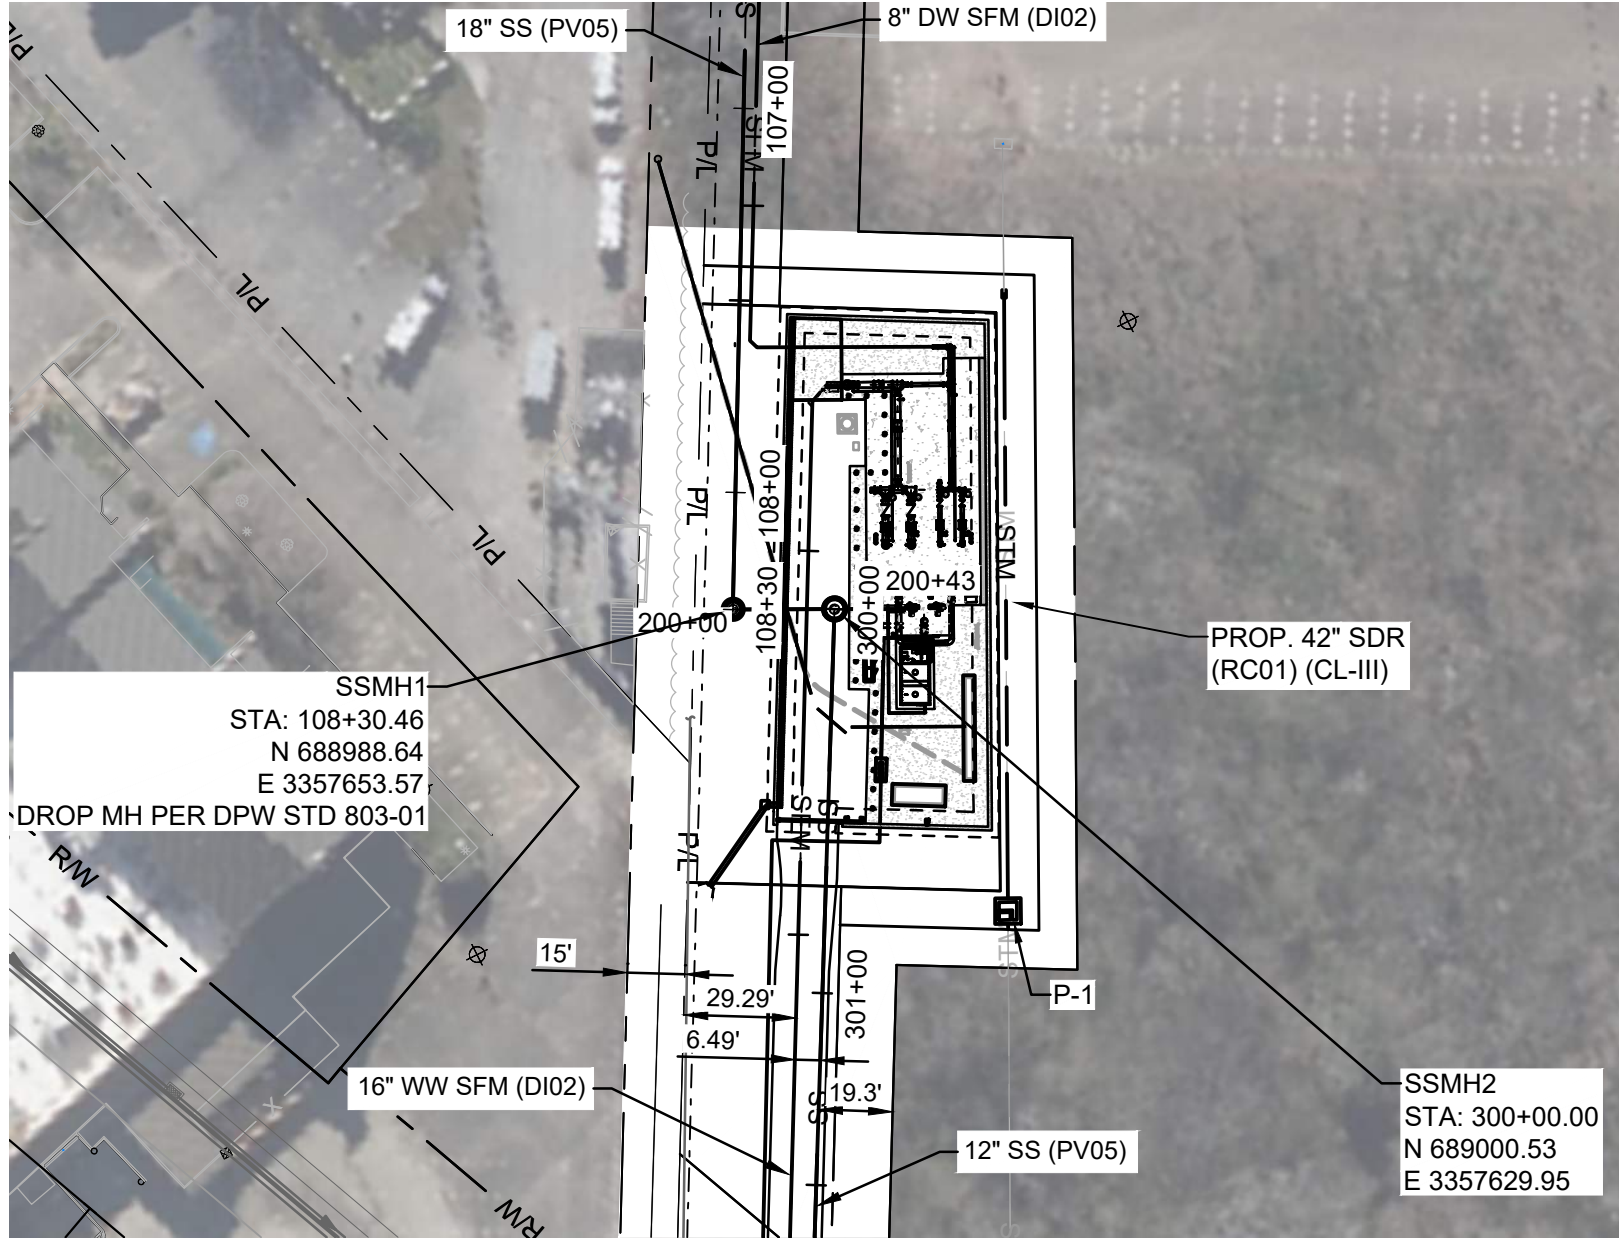 


SSMH1 TO PS299 PLAN

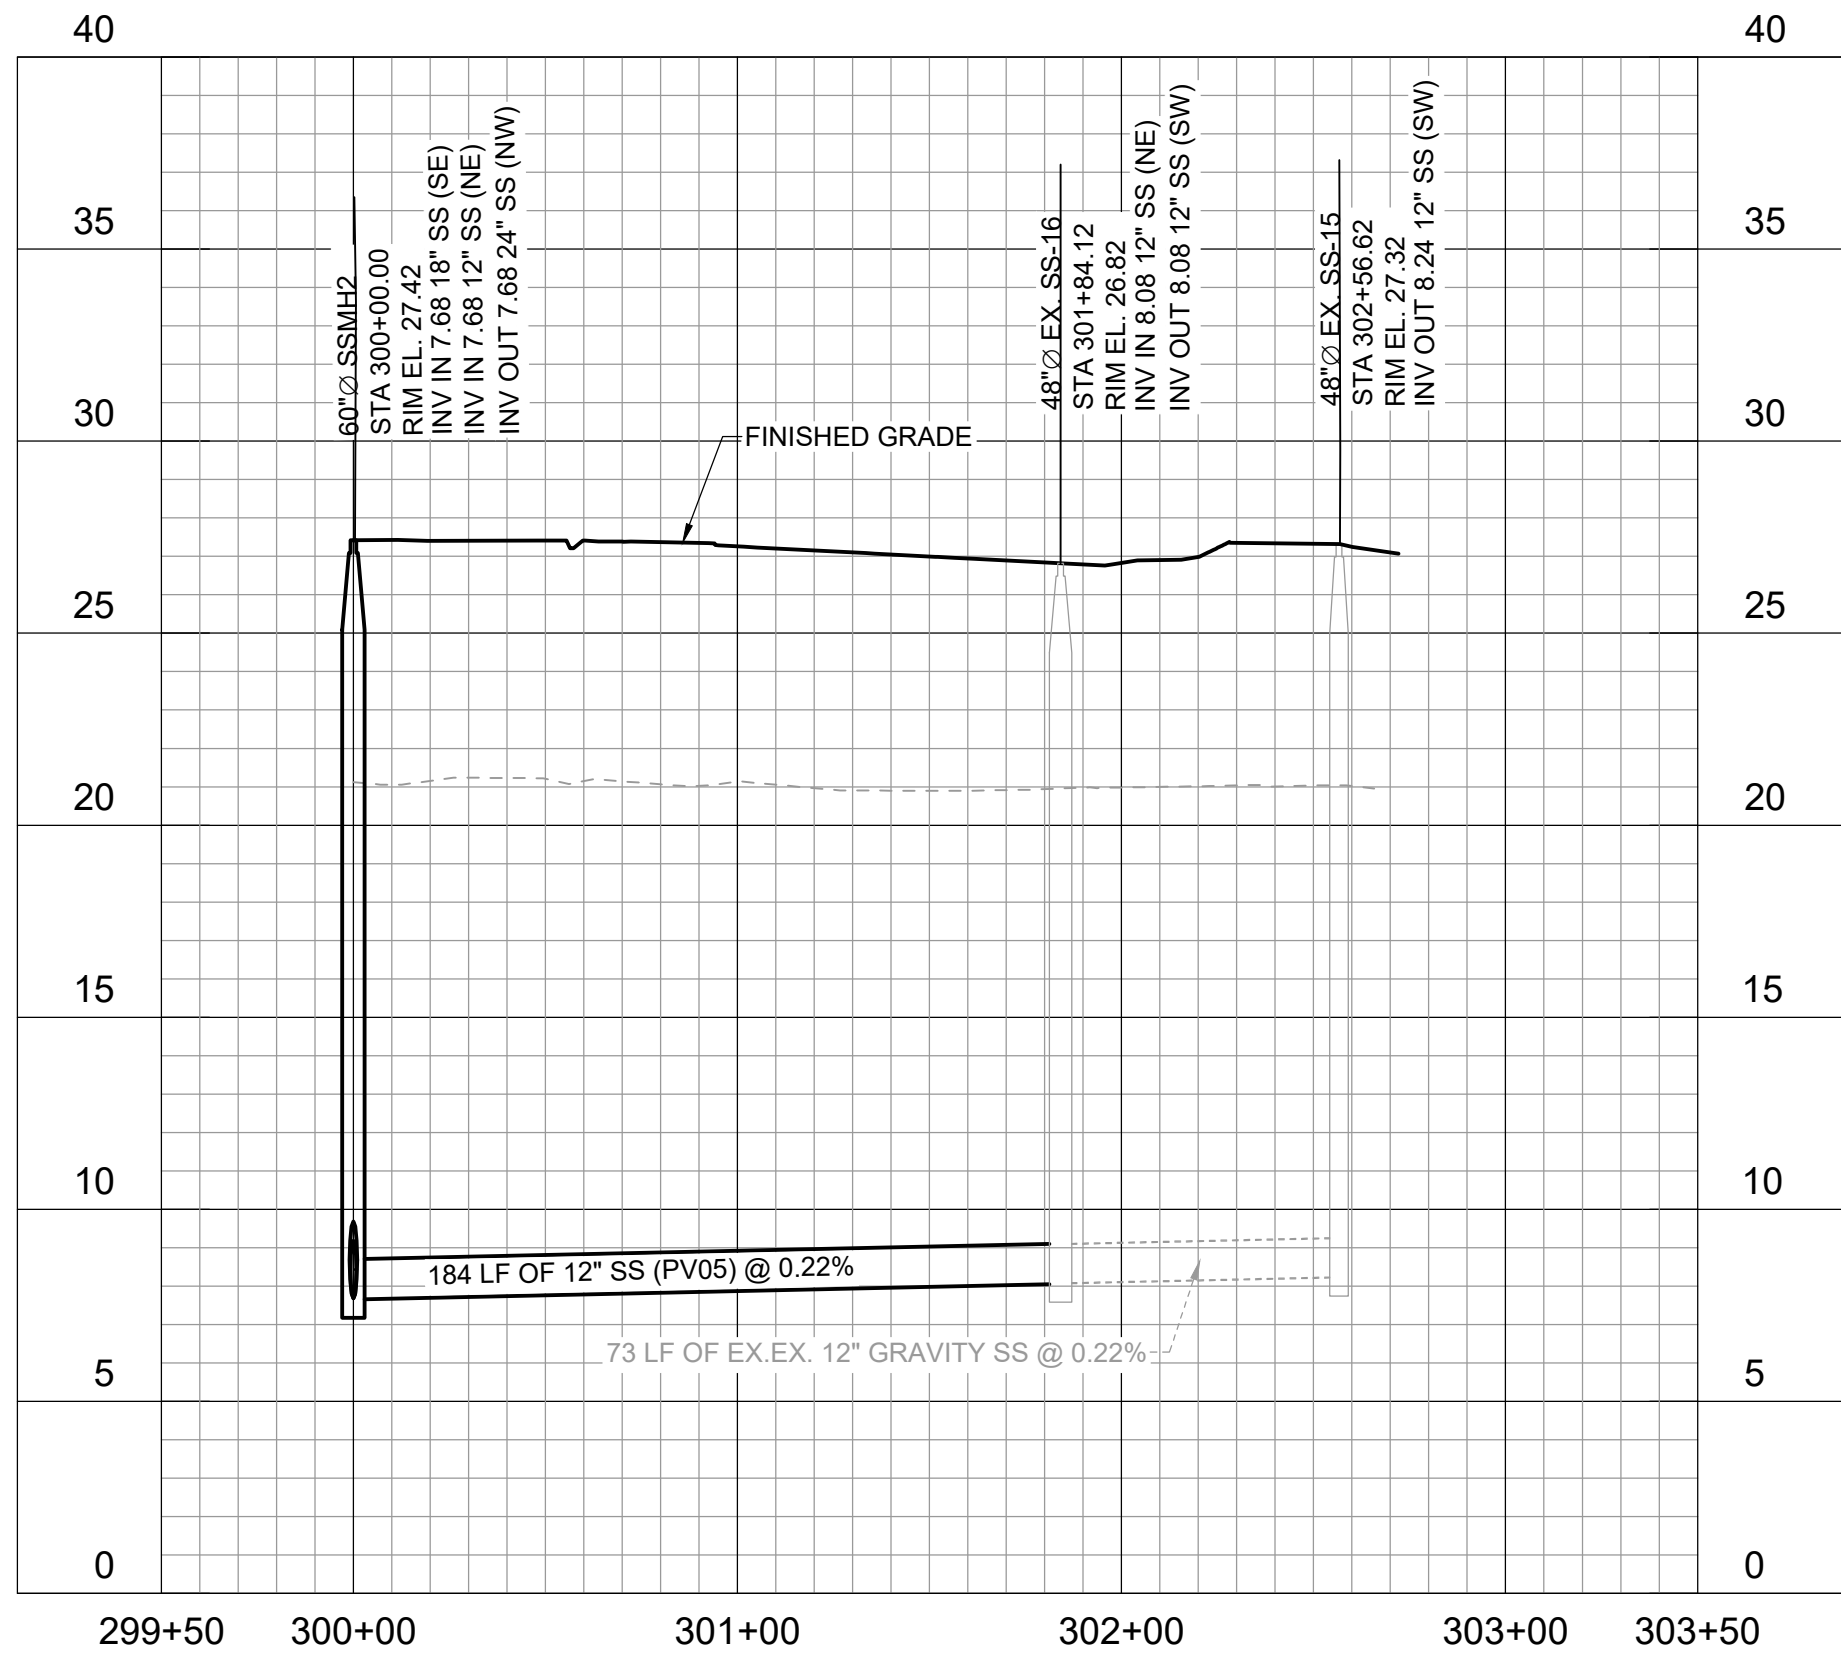 

MH-2 TO EX SS-16 PROFILE

HORIZ SCALE: 1"=50'
VERT SCALE: 1"=5'

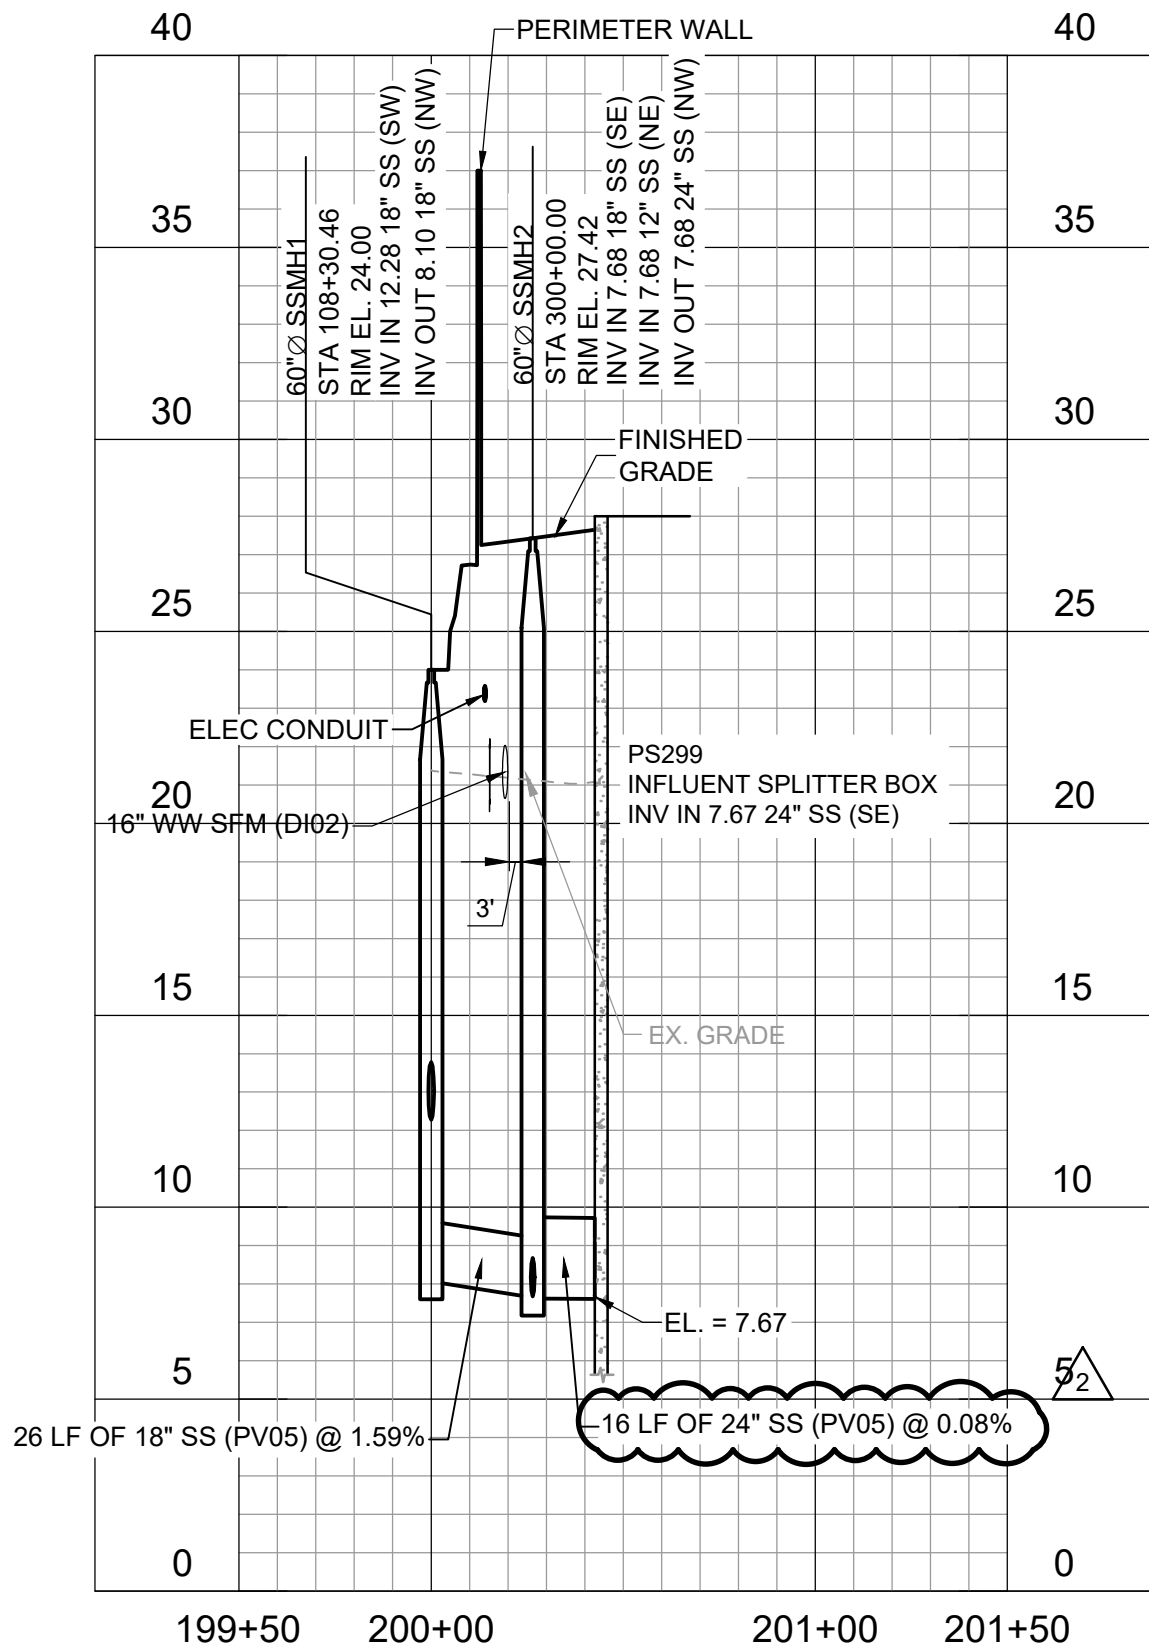

MH-1 TO PS299 PROFILE

HORIZ SCALE: 1"=50'
VERT SCALE: 1"=5'

GENERAL SHEET NOTES

- ALL ELEVATIONS SHOWN HEREIN ARE IN FEET AND REFER TO THE NAVD 1988 DATUM.
- CONTRACTOR SHALL CORE DRILL INTO EXISTING SS-16 MH.
- BACKFILL AND BEDDING PER DPW STD 801-01.
- ALL MANHOLES SHALL INCLUDE 1-FT THICK WALLS, BOTTOM SLABS, AND TOP SLABS. CONTRACTOR SHALL SUBMIT SIGNED & SEALED STRUCTURAL CALCULATIONS.
- GRAVITY PIPE AND APPURTENANCES FROM STATION 301+00.00 TO STATION 301+84.1 AND 300+00 TO 302+57 WILL BE PAID FOR WITH ASSOCIATED UNIT PRICES. ALL OTHER WORK INCLUDED SHALL BE INCLUDED IN THE PRICE SUBMITTED FOR THE PUMP STATION WMP-SUM.


SHEET NUMBER	27
DESIGNED	LH
CHECKED	GB
DATE	10/18/2024
SHEET	27 OF 101
PROJECT	20-PS-IF-0109
STATE	H.012232
REVISION	
NO.	
DATE	
DESCRIPTION	
ISSUED FOR BID	
ADDENDUM NO. 1	
ADDENDUM NO. 2	
ADDENDUM NO. 2R	
DATE	10/27/2025




CIVIL
SEWER PLAN AND PROFILE -II
PS299 REGIONAL PUMP STATION




C-19R

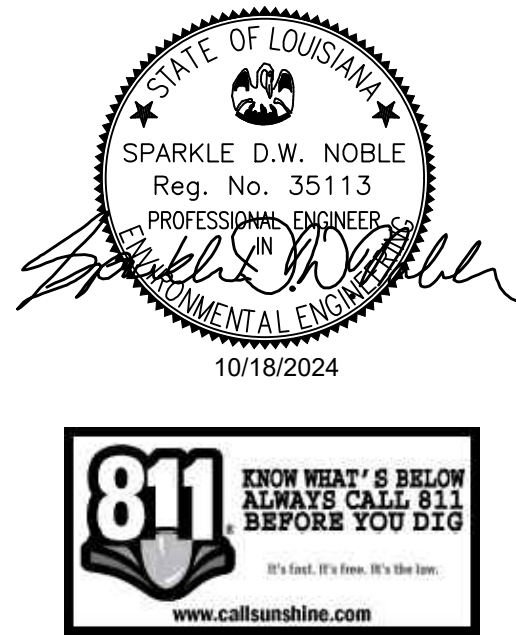

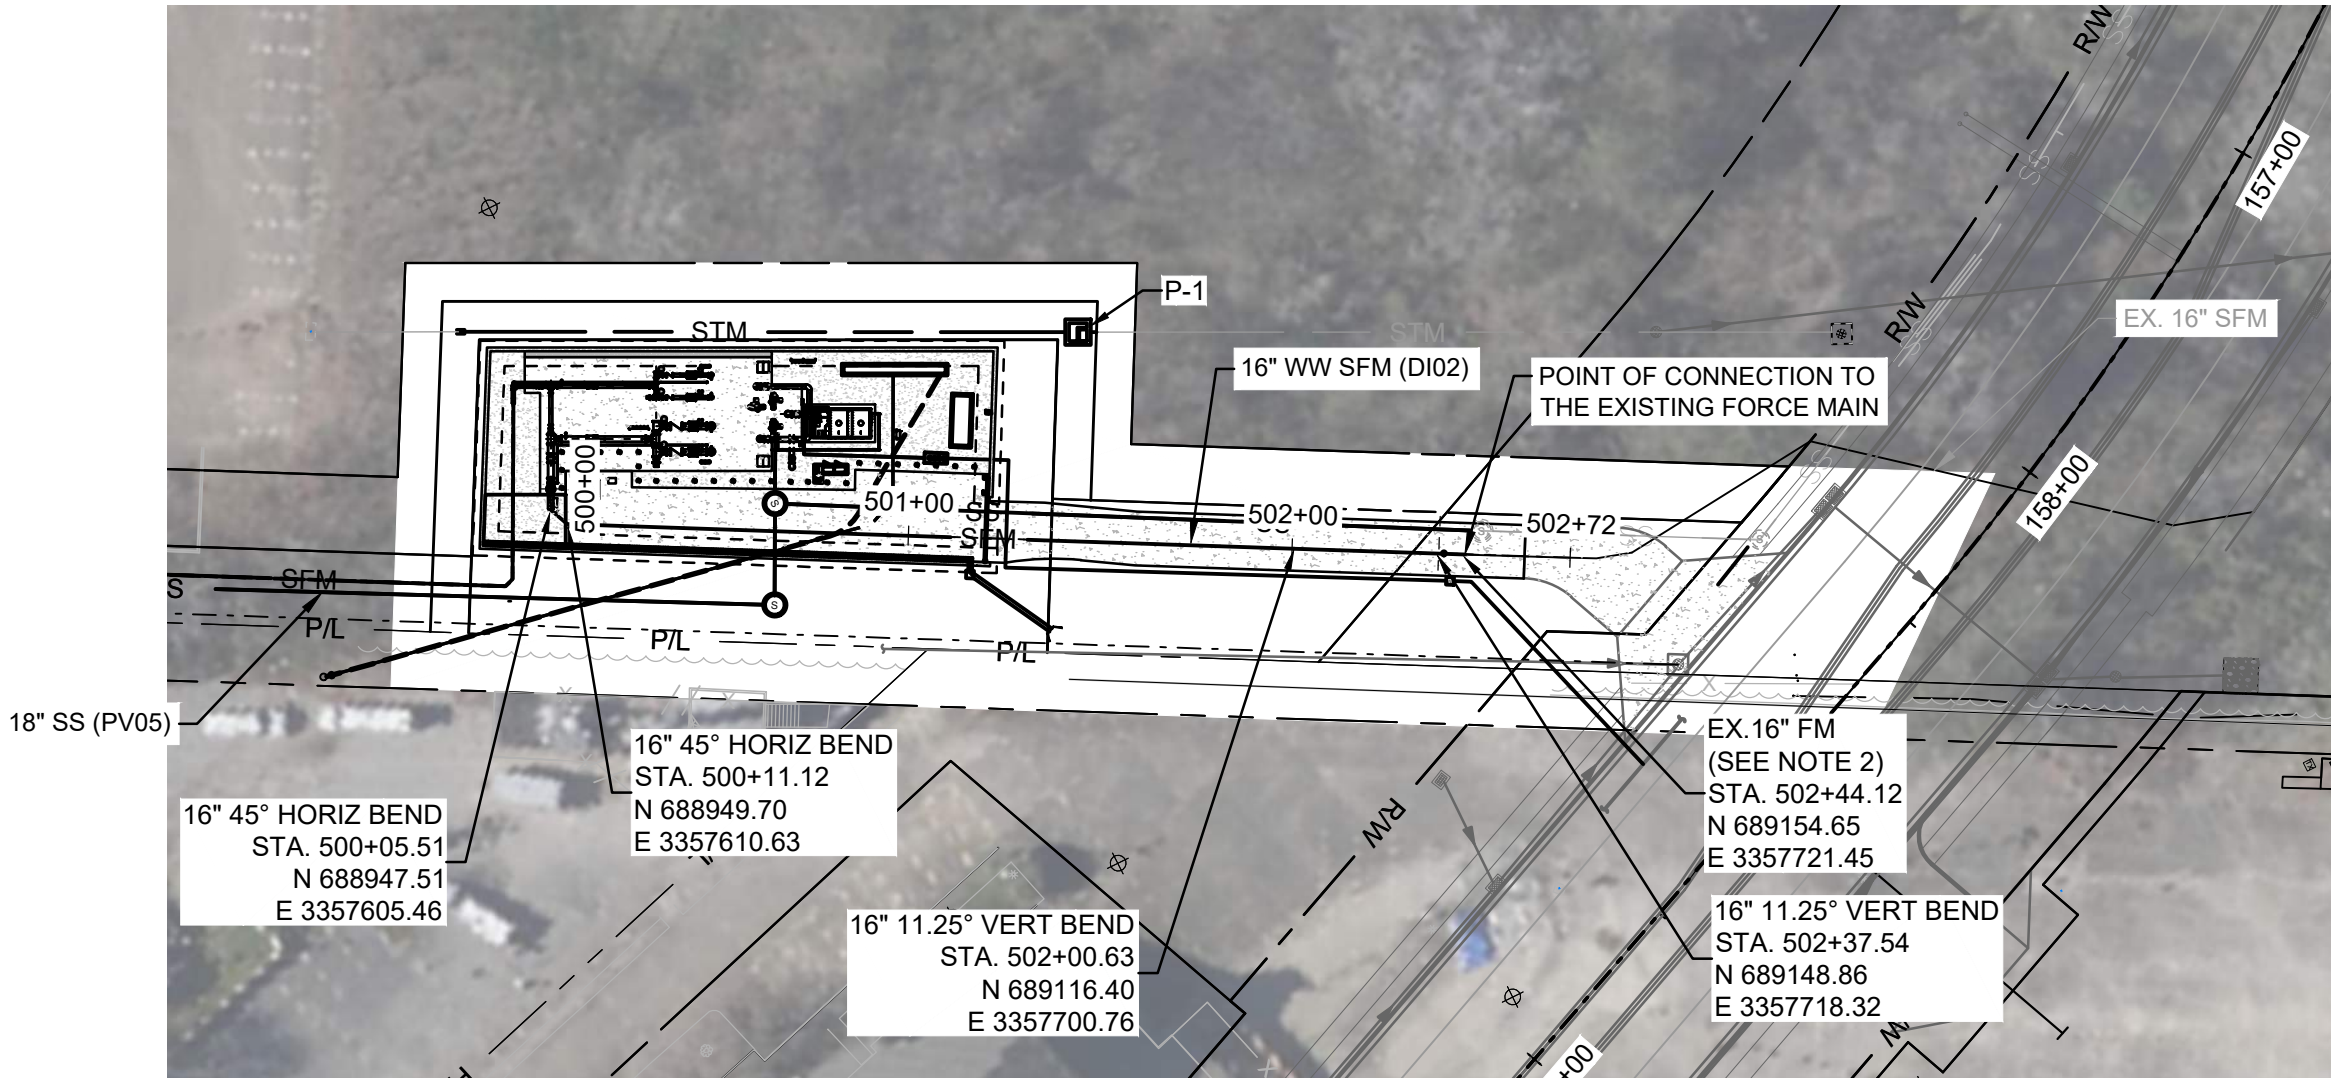


PLAN

0 50 100
SCALE IN FEET

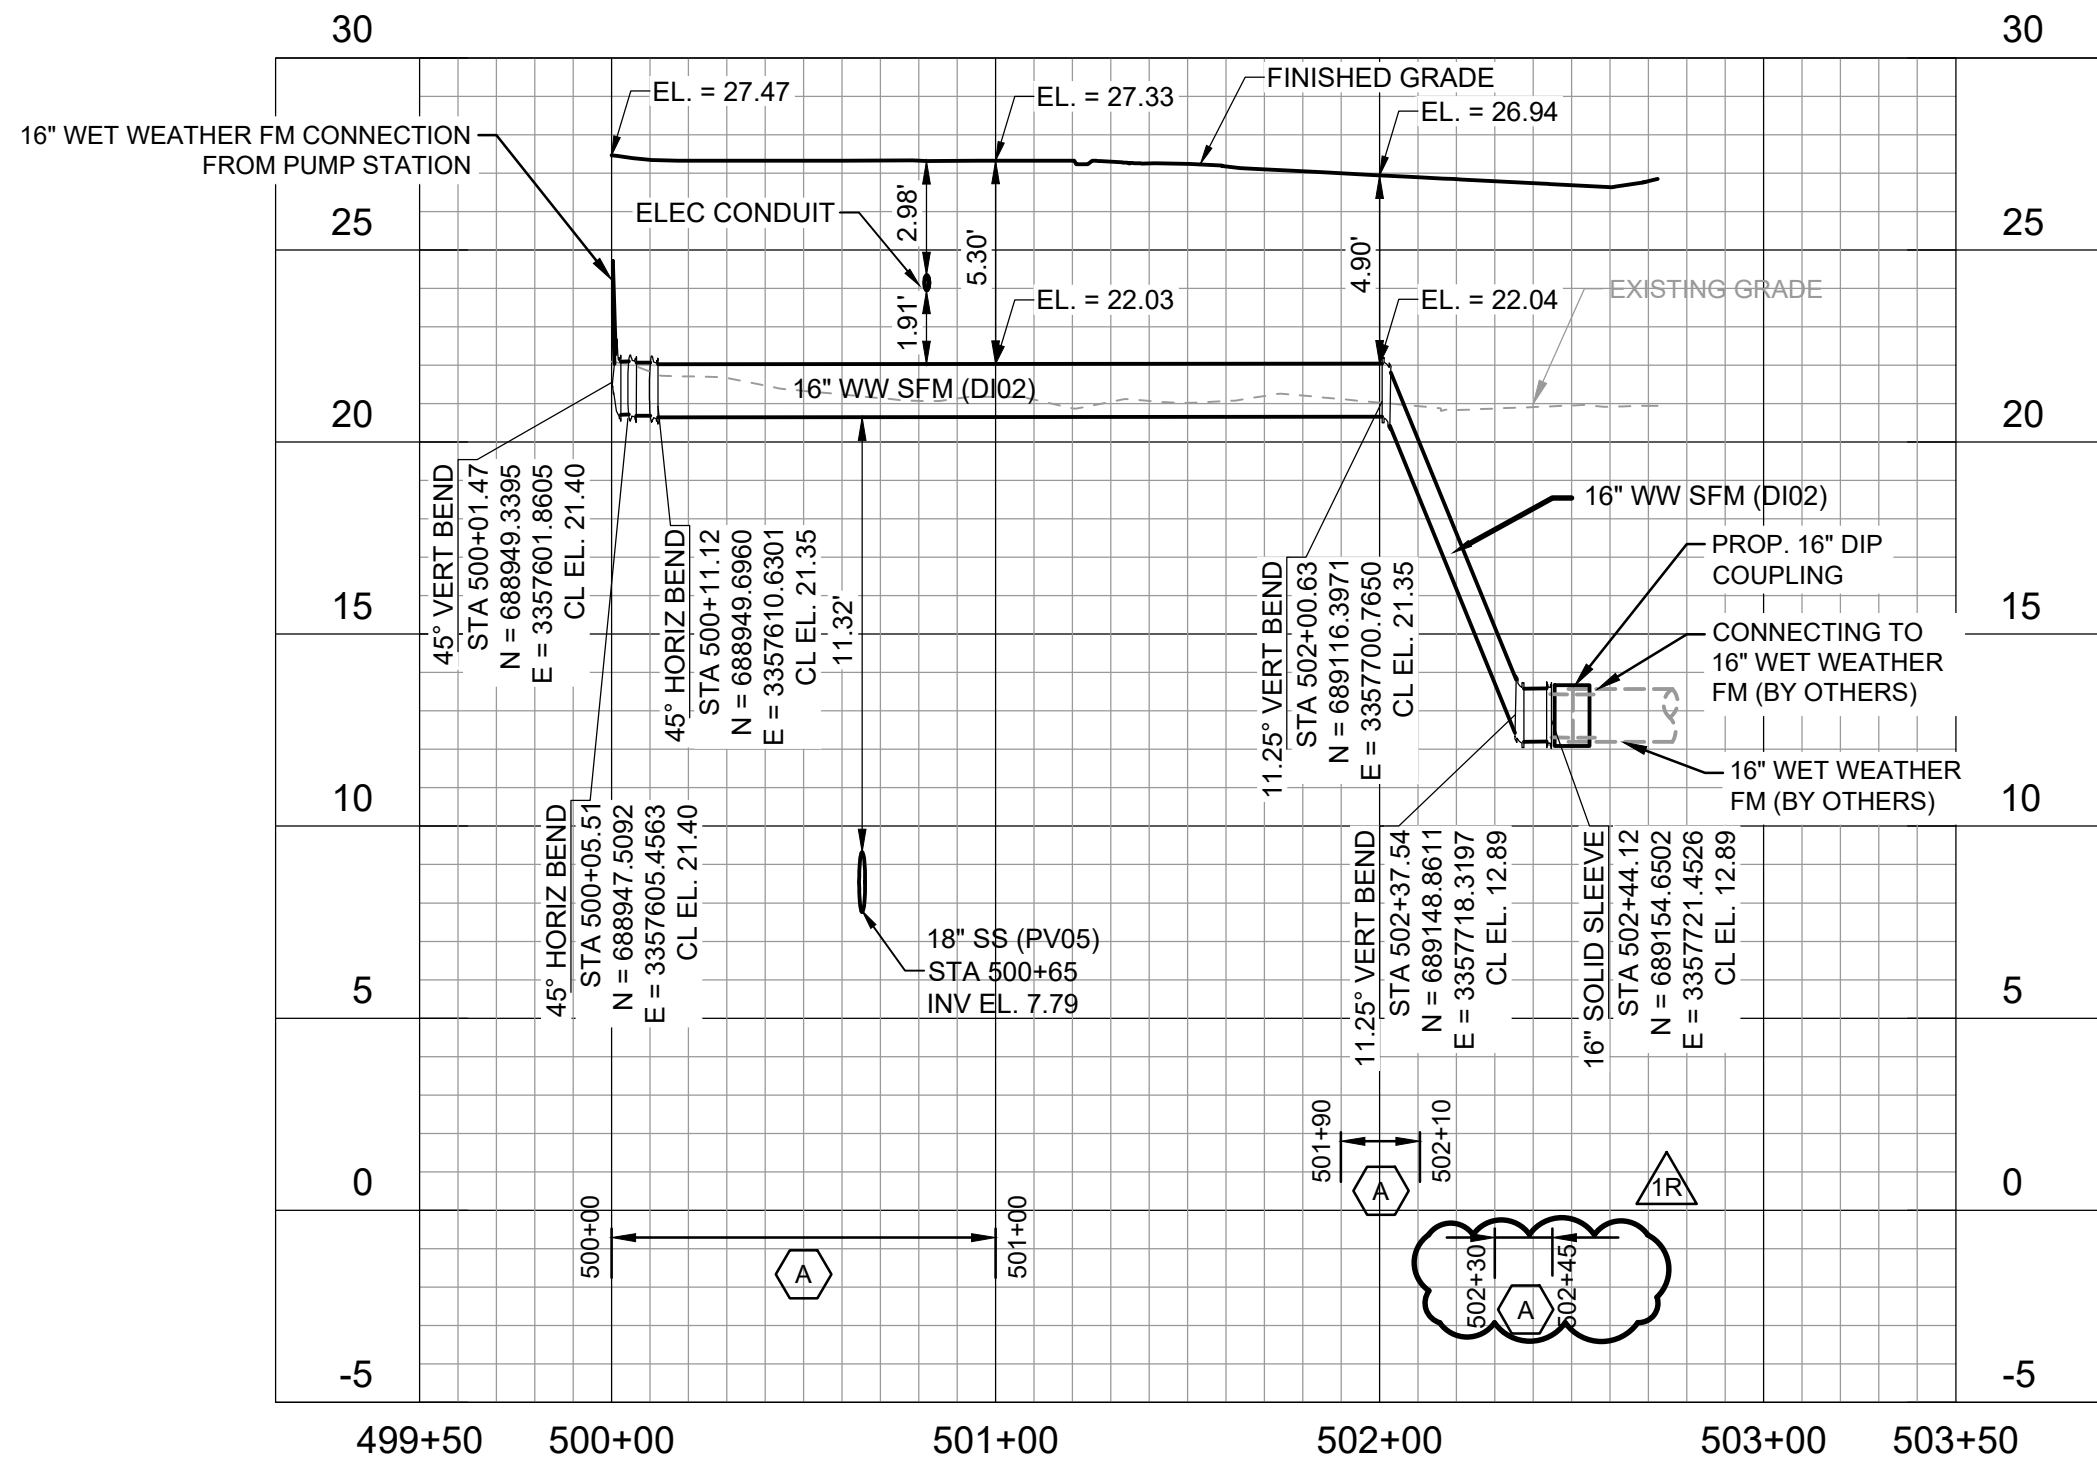

16" WET WEATHER FORCE MAIN PROFILE

HORIZ SCALE: 1"=50'
VERT SCALE: 1"=5'

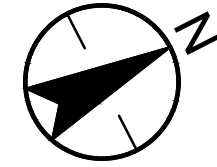

GENERAL SHEET NOTES

- ALL ELEVATIONS SHOWN HEREIN ARE IN FEET AND REFER TO THE NAVD 1988 DATUM.
- CONTRACTOR SHALL COORDINATE FINAL LOCATION WITH ROADWAY CONTRACTOR PRIOR TO INSTALLATION OF FM, REMOVE CAP AND SEE SPECIFICATIONS.
- FORCE MAIN AND ASSOCIATED APPURTENANCES FROM STATION 502+00.63 TO 502+44.12 AND 500+00 TO 503+00 WILL BE PAID FOR WITH ASSOCIATED UNIT PRICES. ALL OTHER WORK INCLUDED SHALL BE INCLUDED IN THE PRICE SUBMITTED FOR THE PUMP STATION LUMP SUM.

SHEET KEYNOTES

- A. RESTRAIN ALL PIPES, FITTINGS, AND VALVES WITHIN STATIONS STATED.

SHEET NUMBER	29
DESIGNED	LM
CHECKED	CIVIL
DATE	10/18/2024
BY	29 OF 101
ADDENDUM NO. 2R	10/27/2025
ADDENDUM NO. 1R	10/17/2025
ADDENDUM NO. 1	11/05/2024
ISSUED FOR BID	10/18/2024
REVISION DESCRIPTION	DATE



CIVIL
WET WEATHER FM PLAN AND PROFILE
PS299 REGIONAL PUMP STATION

