



"RE-BUILDING THE CITY'S WATER SYSTEMS FOR THE 21ST CENTURY"

Sewerage & Water Board OF NEW ORLEANS

625 ST. JOSEPH STREET
NEW ORLEANS, LA 70165 • 504-529-2837 OR 52-WATER
www.swbno.org

Addendum No. 2

Date: 11/10/2025

Your reference is directed to **Contract Number:** 2025-SWB-90 (Contract 5264) for Overhaul of Old Carrollton Underpass Pumping Station which is scheduled to open at **11:30 a.m. CST** on **December 9, 2025.**

This addendum provides for the following:

1. Revision of Louisiana Uniform Public Work Bid Form
2. Updating the EDBP requirements to 15%
3. Revisions to Drawings
4. Updating contract times

-
1. Revision of Louisiana Uniform Public Work Bid Form, *Section 0041 13-2, pg. 30 (please see attached)*
 2. EDBP requirement Percentage is 15% participation (*pages 42 and 44*)
 3. Revisions to Drawings to provide clarification (*please see attached*).
 4. Contract times have been updated to a 60-day contract period, *Section 2.2, pg. 45.*

The above revisions shall be incorporated in and take precedence over any conflicting part of the original proposal documents. This addendum is hereby officially made a part of the referenced proposal.

Receipt of this addendum shall be acknowledged by inserting its number and date in the space provided on the Louisiana Uniform Public Works Bid Form.

This addendum consists of one (1) page and eight (8) attachments.

*** END OF ADDENDUM ***

LOUISIANA UNIFORM PUBLIC WORK BID FORM

UNIT PRICE FORM

TO: Sewerage and Water Board of New Orleans
Purchasing Department, Rm 133
625 St. Joseph St
New Orleans, LA 70165

BID FOR: Contract 5264
Overhaul of Old Carrollton
Underpass Pumping Station

UNIT PRICES: This form shall be used for any and all work required by the Bidding Documents and described as unit prices. Amounts shall be stated in figures and only in figures.

DESCRIPTION:	☒ Base Bid or ☐ Alt.# _____			
REF. NO.	QUANTITY:	UNIT OF MEASURE:	UNIT PRICE	UNIT PRICE EXTENSION (<i>Quantity times Unit Price</i>)
1		Lump Sum		

DESCRIPTION:	☒ Base Bid or ☐ Alt.# _____			
REF. NO.	QUANTITY:	UNIT OF MEASURE:	UNIT PRICE	UNIT PRICE EXTENSION (<i>Quantity times Unit Price</i>)
2		Lump Sum		

DESCRIPTION:	☒ Base Bid or ☐ Alt.# _____			
REF. NO.	QUANTITY:	UNIT OF MEASURE:	UNIT PRICE	UNIT PRICE EXTENSION (<i>Quantity times Unit Price</i>)
3		Lump Sum		

DESCRIPTION:	☒ Base Bid or ☐ Alt.# _____			
REF. NO.	QUANTITY:	UNIT OF MEASURE:	UNIT PRICE	UNIT PRICE EXTENSION (<i>Quantity times Unit Price</i>)
4		Lump Sum		

DESCRIPTION:	☒ Base Bid or ☐ Alt.# _____			
REF. NO.	QUANTITY:	UNIT OF MEASURE:	UNIT PRICE	UNIT PRICE EXTENSION (<i>Quantity times Unit Price</i>)
5		Lump Sum		

DESCRIPTION:	☒ Base Bid or ☐ Alt.# _____			
REF. NO.	QUANTITY:	UNIT OF MEASURE:	UNIT PRICE	UNIT PRICE EXTENSION (<i>Quantity times Unit Price</i>)
6		Lump Sum		

DESCRIPTION:	☒ Base Bid or ☐ Alt.# _____			
REF. NO.	QUANTITY:	UNIT OF MEASURE:	UNIT PRICE	UNIT PRICE EXTENSION (<i>Quantity times Unit Price</i>)
7		Lump Sum		



DESCRIPTION:	☐ Base Bid or ☒ Alt.# _____			
REF. NO.	QUANTITY:	UNIT OF MEASURE:	UNIT PRICE	UNIT PRICE EXTENSION (<i>Quantity times Unit Price</i>)
8		Lump Sum		

DESCRIPTION:	☐ Base Bid or ☒ Alt.# _____			
REF. NO.	QUANTITY:	UNIT OF MEASURE:	UNIT PRICE	UNIT PRICE EXTENSION (<i>Quantity times Unit Price</i>)
9		Lump Sum		

Wording for "DESCRIPTION" is provided by the Owner.


All quantities are estimated. The contractor will be paid based upon actual quantities as verified by the Owner

SEWERAGE AND WATER BOARD
OF NEW ORLEANS

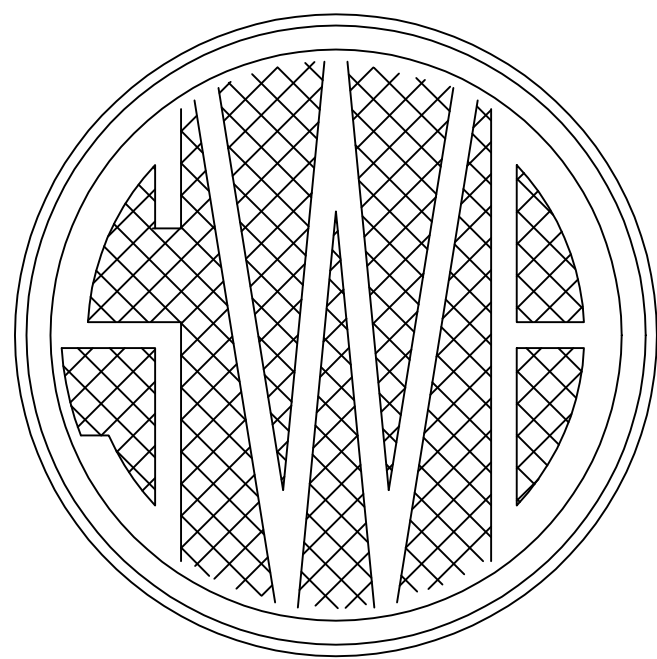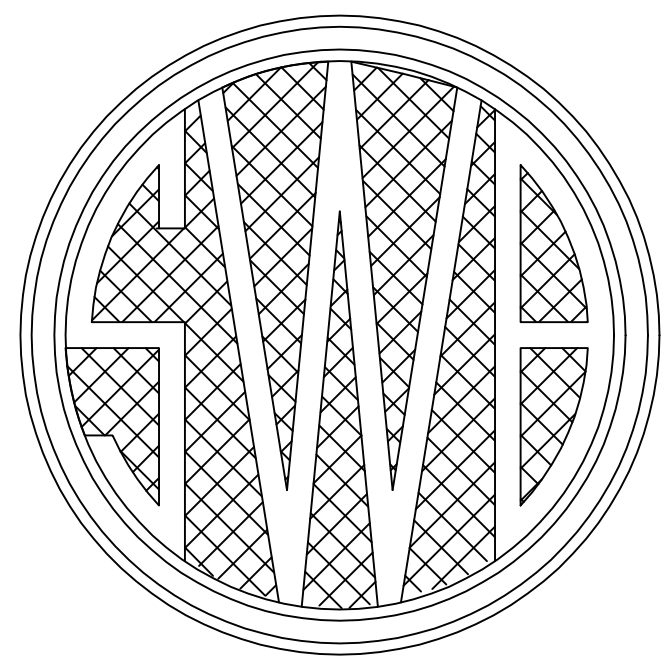

ENGINEERING DEPARTMENT



CONTRACT 5264
OVERHAUL OF OLD CARROLLTON UNDERPASS
PUMPING STATION

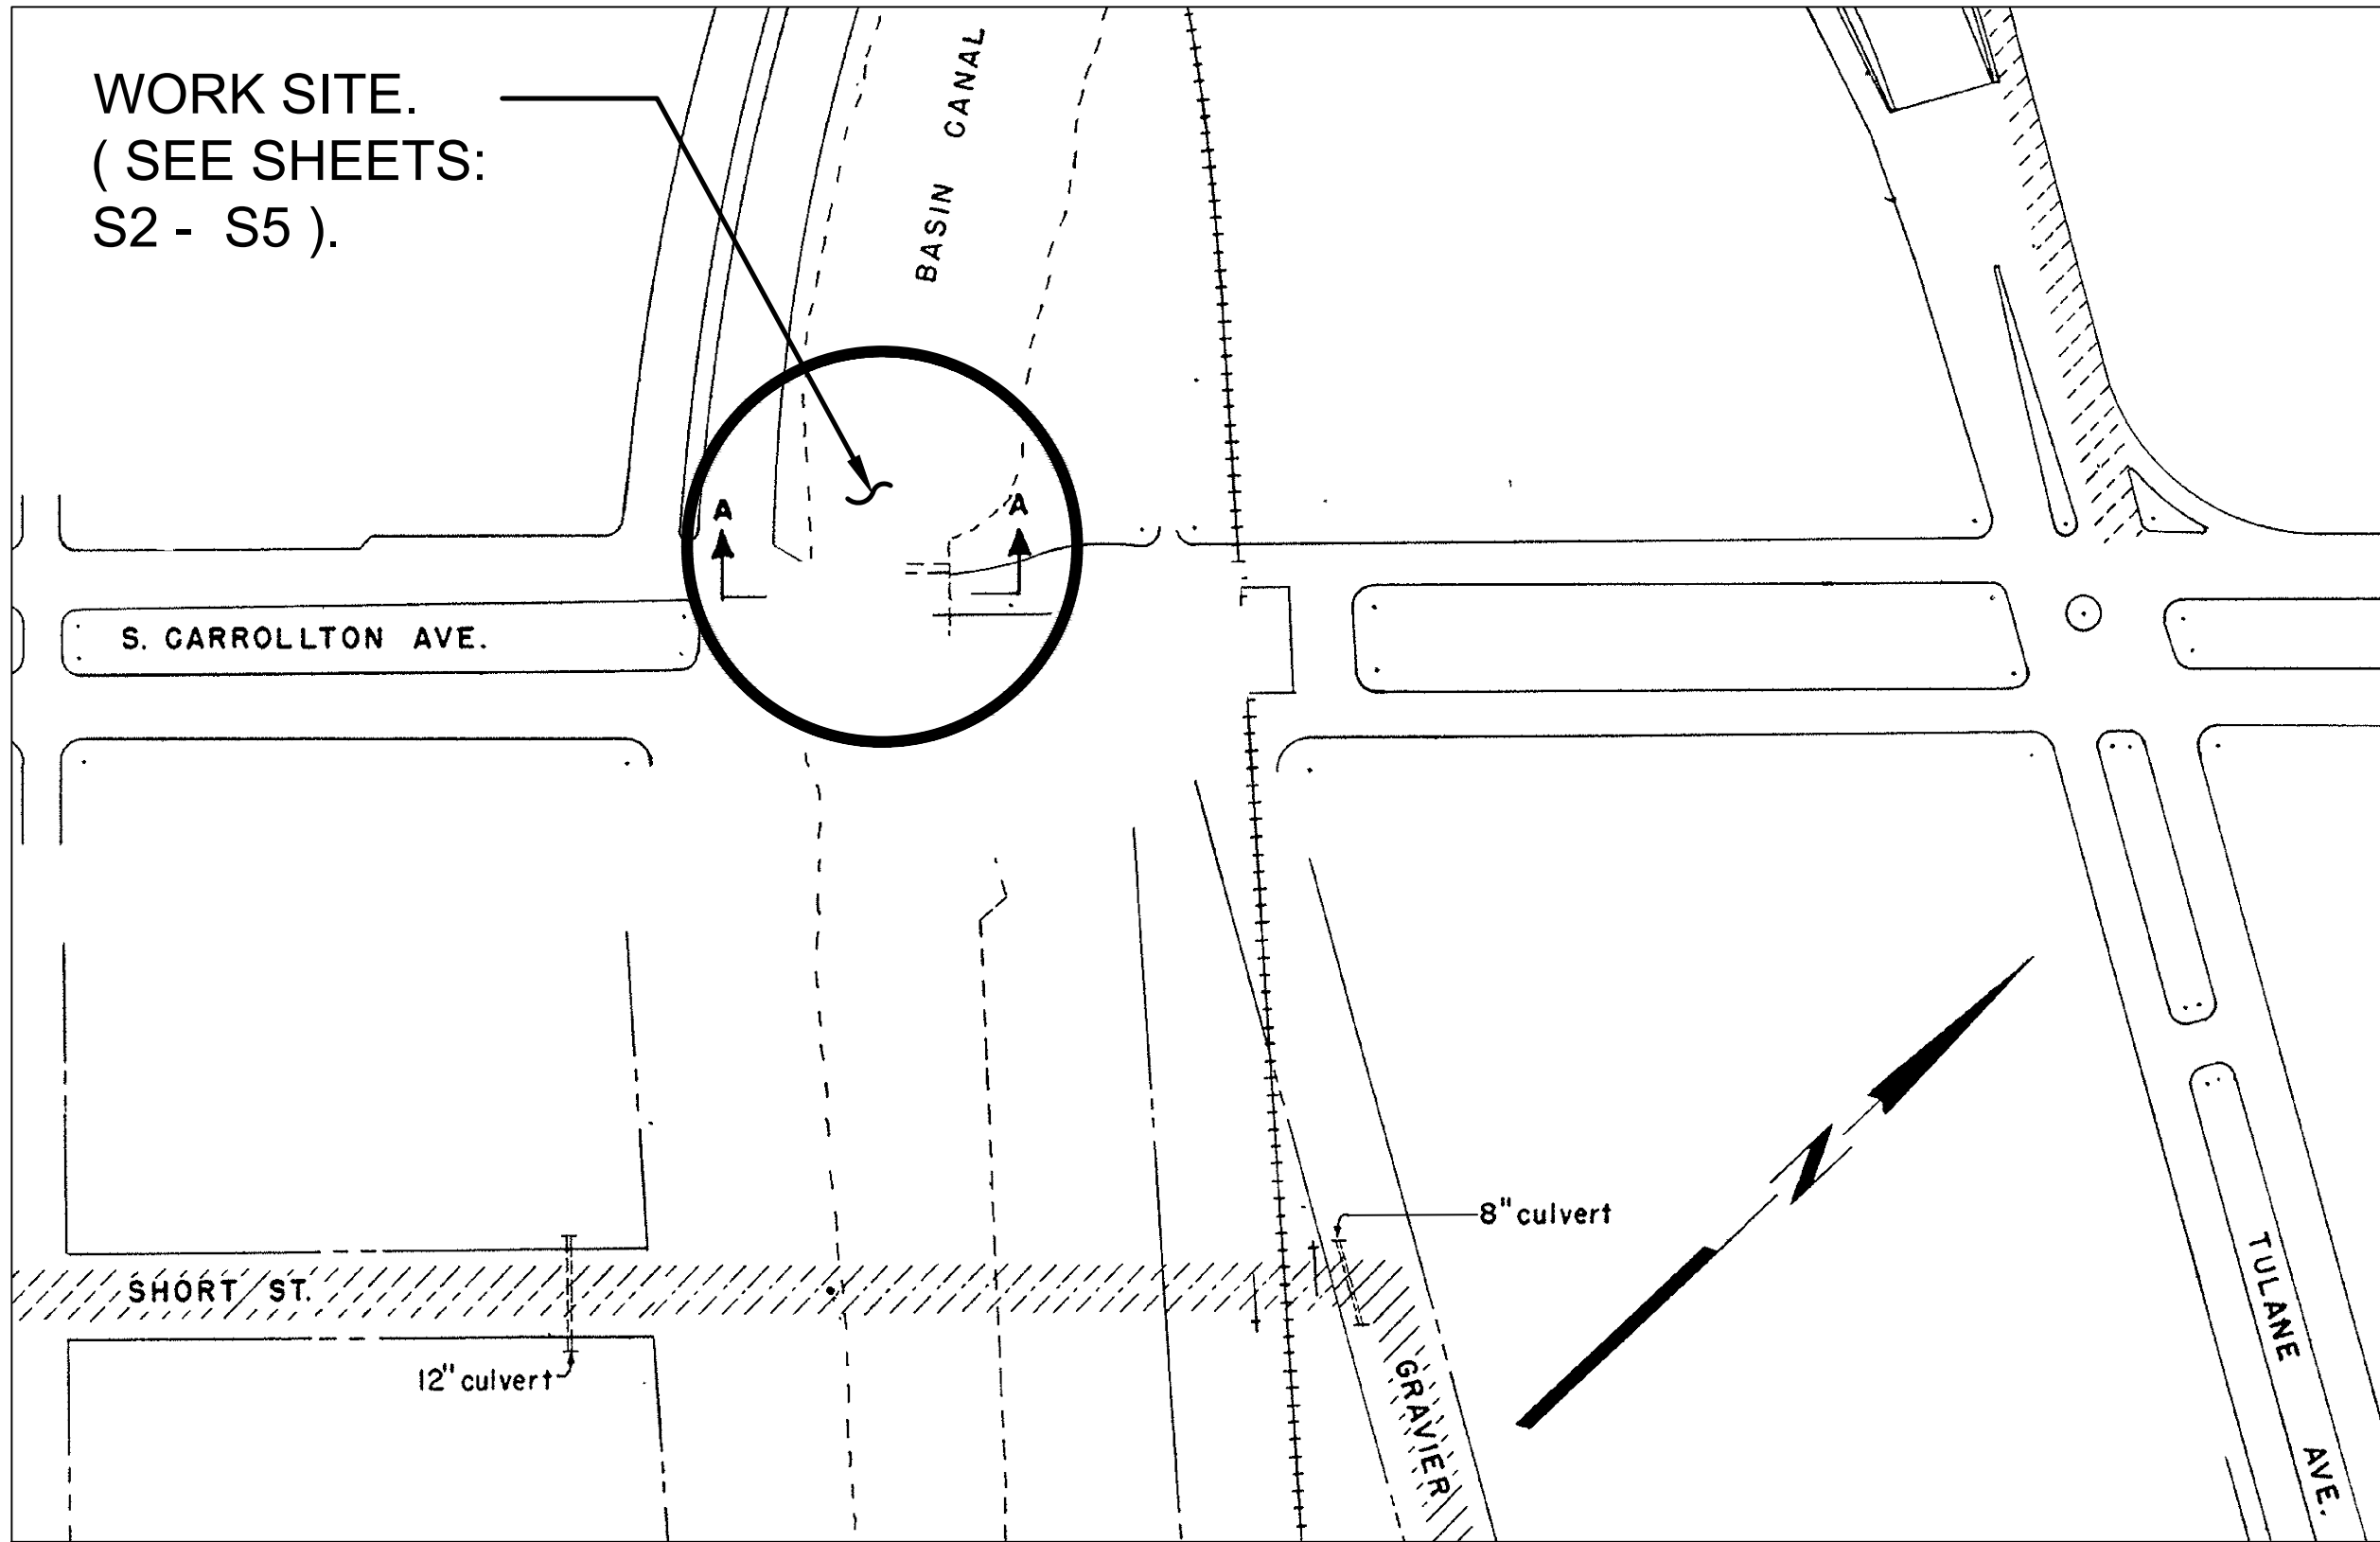

LOCATION MAP
N.T.S.

DRAWING INDEX		
SHEET No.	TITLE	REFERENCE DWG. #
T-1	TITLE SHEET, LOCATION MAP, AND DRAWING INDEX	11357-W-18 SHEET #2
S-2	SITE PLAN	11982-W-29 SHEET #2
S-3	UTILITY SITE PLAN	12144-W-27 SHEET #13
S-4	SURVEY	12138-W-29 SHEET #44
S-5	ELECTRIC SITE PLAN	5091-P15
S-6	EXISTING AND NEW PLAN VIEW SECTIONS, NEW ELEVATION SECTION	11982-W-29 SHEET #3
S-7	NEW PLAN VIEW SECTION, NEW ELEVATION SECTION AND DETAILS	11982-W-29 SHEET #3
S-8		
S-9		
S-10		
S-11		

REV.	DATE	DESCRIPTION	BY
SEWERAGE AND WATER BOARD OF NEW ORLEANS			
CONTRACT 5264 OVERHAUL OF OLD CARROLLTON UNDERPASS PUMPING STATION			
TITLE SHEET			
DR.	NFB	T-1	
TRC.	XX		
CHK.	TS		
APP.	TS		
SCALE:	AS NOTED	DWG. No. 12303-W-18	
DATE:	11/05/2025	SHEET NO.	1-OF-7

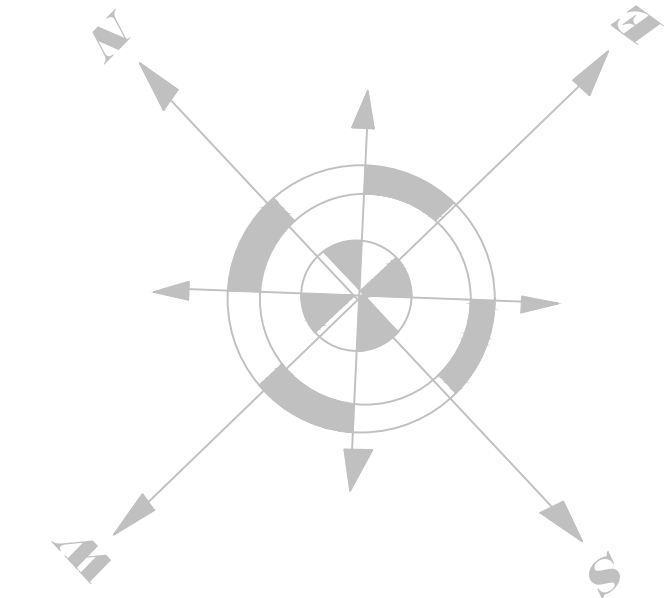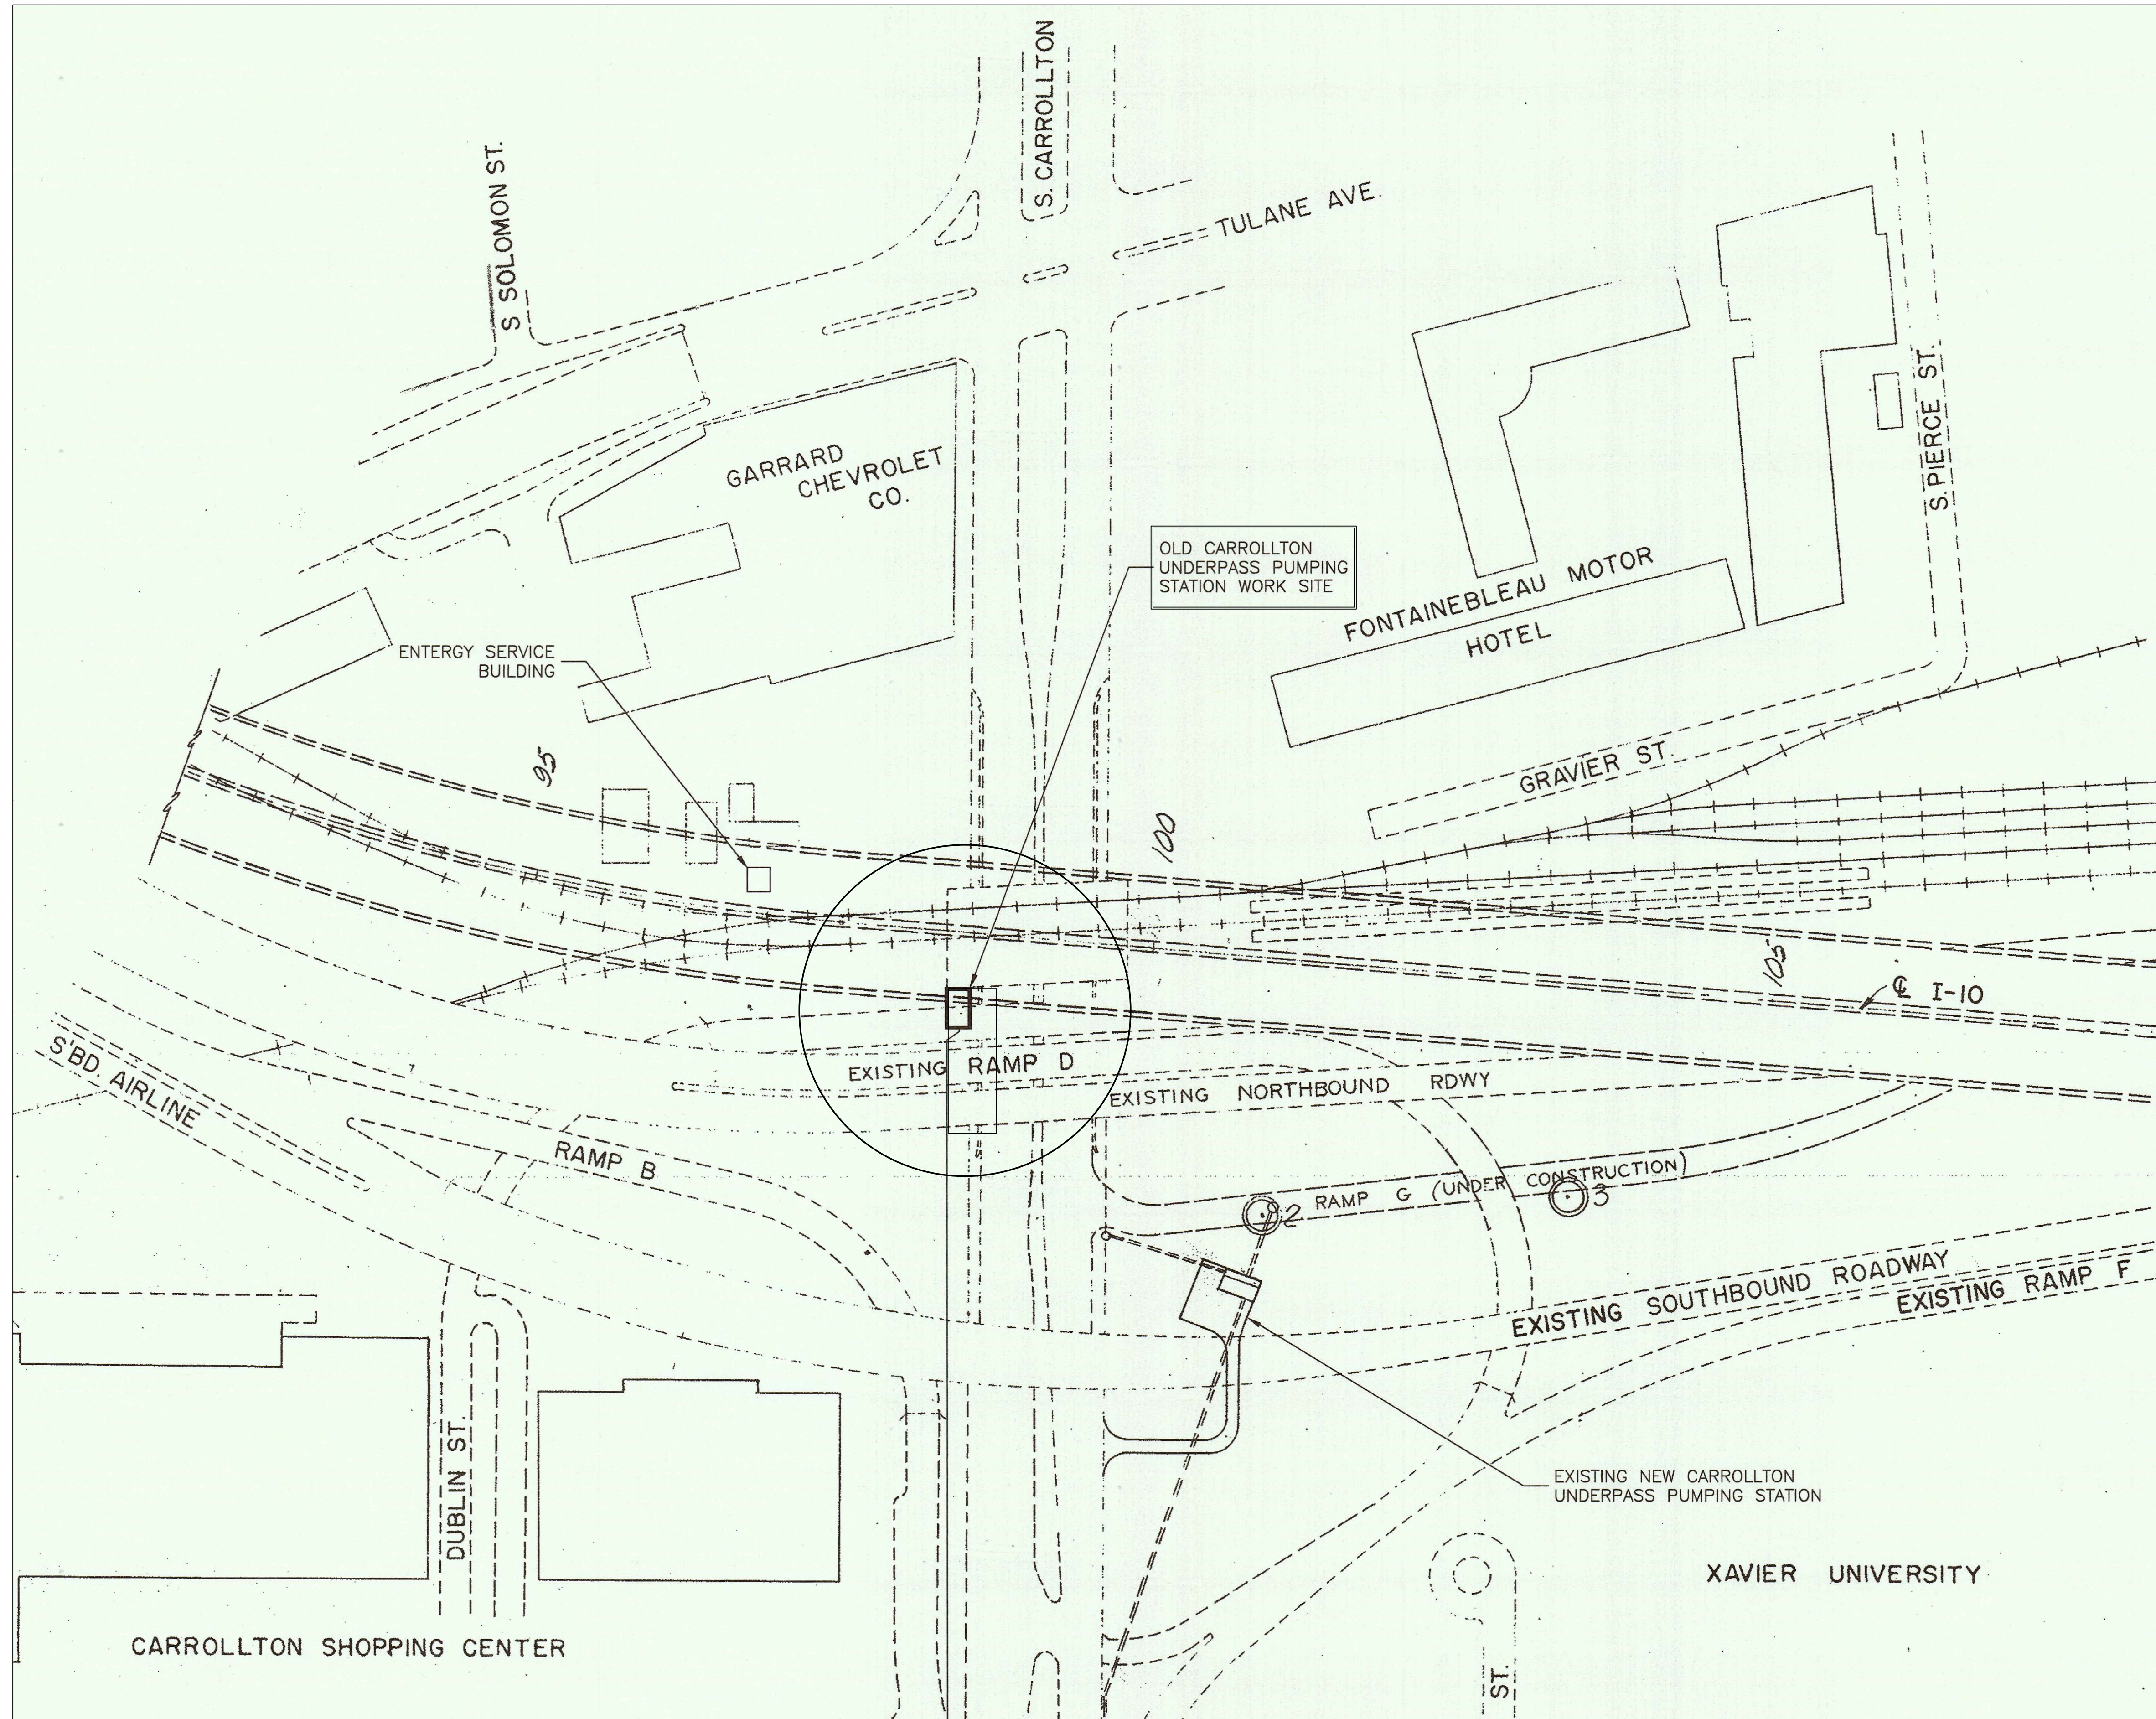


SITE PLAN
N.T.S.


REFERENCE INFO ONLY

REFERENCE DWG.11982-W-29 SHT. # 2

REV.	DATE	DESCRIPTION	BY
SEWERAGE AND WATER BOARD OF NEW ORLEANS			
CONTRACT 5264			
OVERHAUL OF OLD CARROLLTON UNDERPASS PUMPING STATION			
SITE PLAN			
DR.	NFB	S-2	
TRC.	XX		
CHK.	TS		
APP.	TS	DWG. No. 12303-W-18	
SCALE:	AS NOTED		
DATE:	11/05/2025	SHEET NO.	2-OF-7

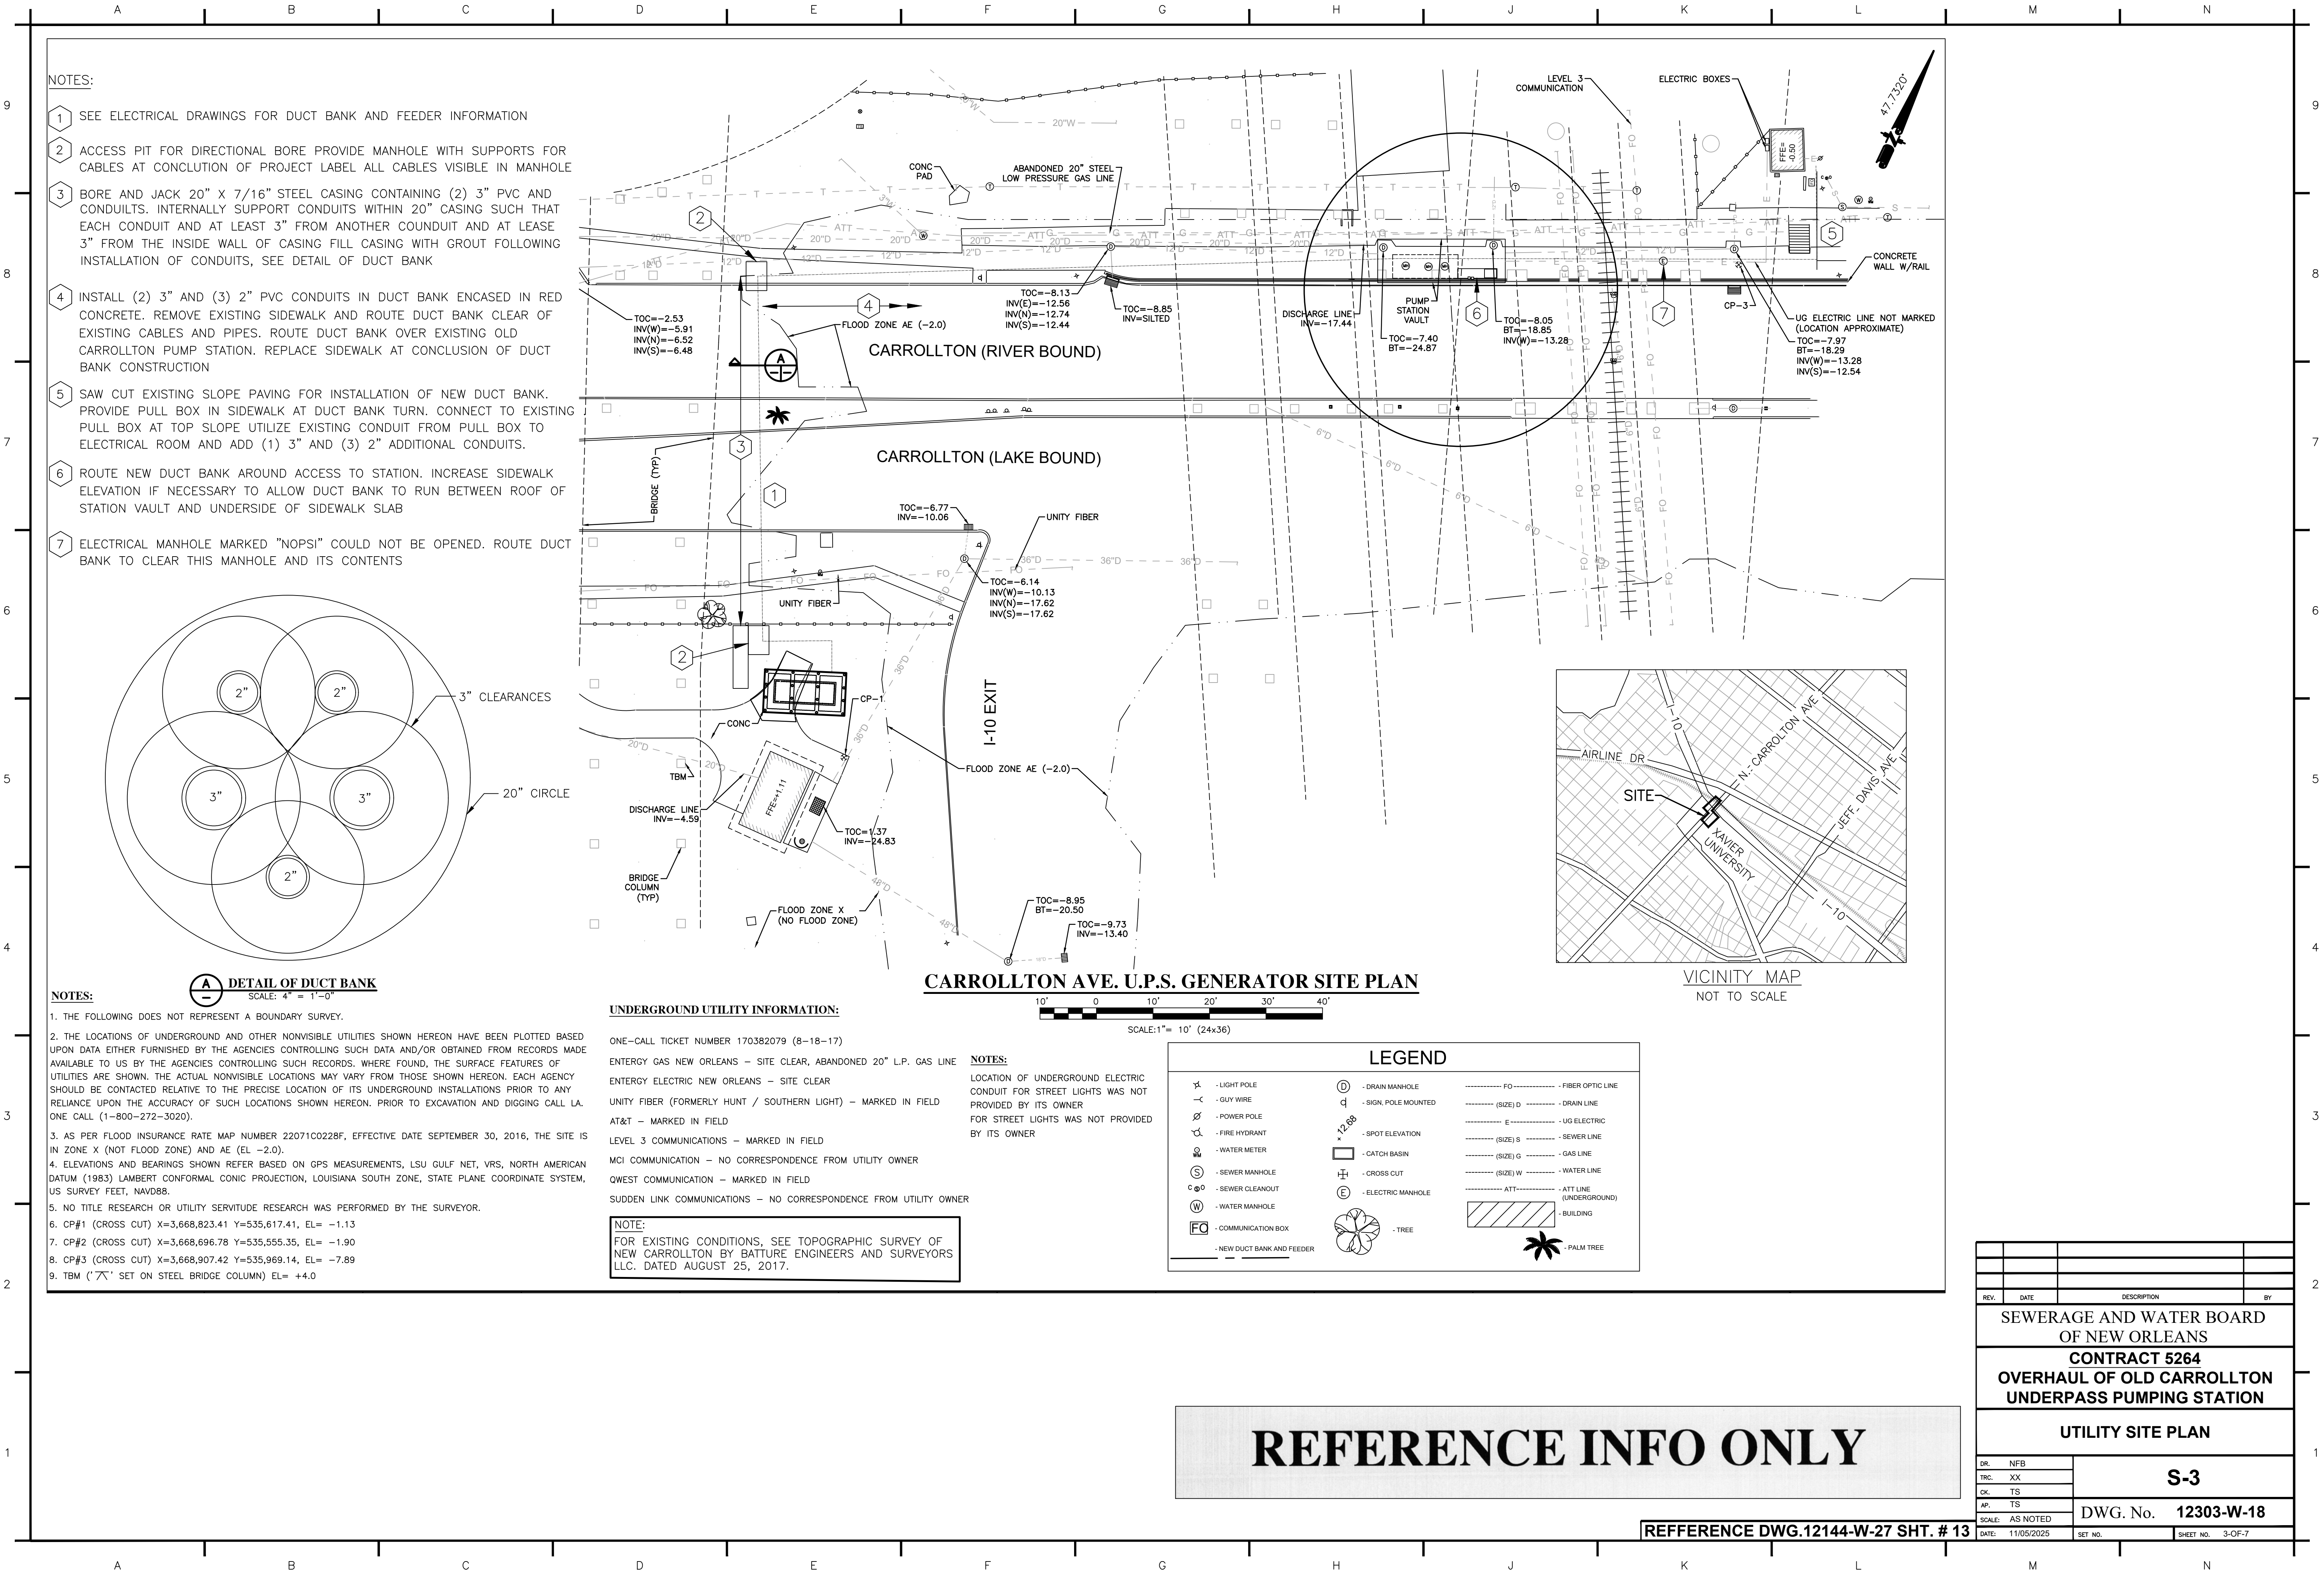

- NOTES:
- SEE ELECTRICAL DRAWINGS FOR DUCT BANK AND FEEDER INFORMATION
 - ACCESS PIT FOR DIRECTIONAL BORE PROVIDE MANHOLE WITH SUPPORTS FOR CABLES AT CONCLUSION OF PROJECT LABEL ALL CABLES VISIBLE IN MANHOLE
 - BORE AND JACK 20" X 7/16" STEEL CASING CONTAINING (2) 3" PVC AND CONDUITS. INTERNALLY SUPPORT CONDUITS WITHIN 20" CASING SUCH THAT EACH CONDUIT AND AT LEAST 3" FROM ANOTHER CONDUIT AND AT LEAST 3" FROM THE INSIDE WALL OF CASING FILL CASING WITH GROUT FOLLOWING INSTALLATION OF CONDUITS, SEE DETAIL OF DUCT BANK
 - INSTALL (2) 3" AND (3) 2" PVC CONDUITS IN DUCT BANK ENCASED IN RED CONCRETE. REMOVE EXISTING SIDEWALK AND ROUTE DUCT BANK CLEAR OF EXISTING CABLES AND PIPES. ROUTE DUCT BANK OVER EXISTING OLD CARROLLTON PUMP STATION. REPLACE SIDEWALK AT CONCLUSION OF DUCT BANK CONSTRUCTION
 - SAW CUT EXISTING SLOPE PAVING FOR INSTALLATION OF NEW DUCT BANK. PROVIDE PULL BOX IN SIDEWALK AT DUCT BANK TURN. CONNECT TO EXISTING PULL BOX AT TOP SLOPE UTILIZE EXISTING CONDUIT FROM PULL BOX TO ELECTRICAL ROOM AND ADD (1) 3" AND (3) 2" ADDITIONAL CONDUITS.
 - ROUTE NEW DUCT BANK AROUND ACCESS TO STATION. INCREASE SIDEWALK ELEVATION IF NECESSARY TO ALLOW DUCT BANK TO RUN BETWEEN ROOF OF STATION VAULT AND UNDERSIDE OF SIDEWALK SLAB
 - ELECTRICAL MANHOLE MARKED "NOPS!" COULD NOT BE OPENED. ROUTE DUCT BANK TO CLEAR THIS MANHOLE AND ITS CONTENTS

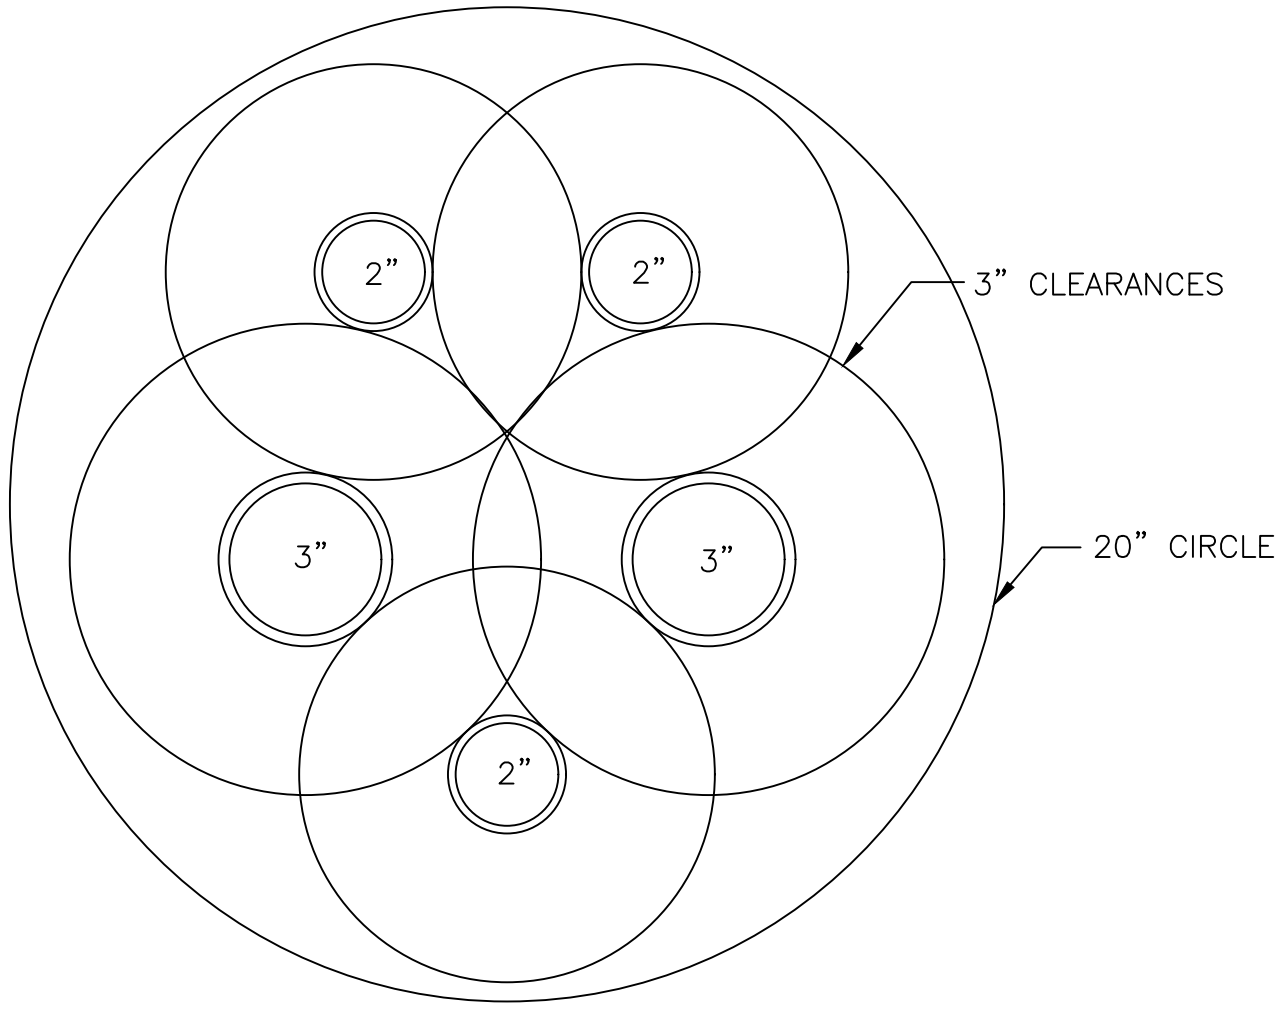

- NOTES:
- THE FOLLOWING DOES NOT REPRESENT A BOUNDARY SURVEY.
 - THE LOCATIONS OF UNDERGROUND AND OTHER NONVISIBLE UTILITIES SHOWN HEREON HAVE BEEN PLOTTED BASED UPON DATA EITHER FURNISHED BY THE AGENCIES CONTROLLING SUCH DATA AND/OR OBTAINED FROM RECORDS MADE AVAILABLE TO US BY THE AGENCIES CONTROLLING SUCH RECORDS. WHERE FOUND, THE SURFACE FEATURES OF UTILITIES ARE SHOWN. THE ACTUAL NONVISIBLE LOCATIONS MAY VARY FROM THOSE SHOWN HEREON. EACH AGENCY SHOULD BE CONTACTED RELATIVE TO THE PRECISE LOCATION OF ITS UNDERGROUND INSTALLATIONS PRIOR TO ANY RELIANCE UPON THE ACCURACY OF SUCH LOCATIONS SHOWN HEREON. PRIOR TO EXCAVATION AND DIGGING CALL LA. ONE CALL (1-800-272-3020).
 - AS PER FLOOD INSURANCE RATE MAP NUMBER 22071C0228F, EFFECTIVE DATE SEPTEMBER 30, 2016, THE SITE IS IN ZONE X (NOT FLOOD ZONE) AND AE (EL. -2.0).
 - ELEVATIONS AND BEARINGS SHOWN REFER BASED ON GPS MEASUREMENTS, LSU GULF NET, VRS, NORTH AMERICAN DATUM (1983) LAMBERT CONFORMAL CONIC PROJECTION, LOUISIANA SOUTH ZONE, STATE PLANE COORDINATE SYSTEM, US SURVEY FEET, NAVD88.
 - NO TITLE RESEARCH OR UTILITY SERVITUDE RESEARCH WAS PERFORMED BY THE SURVEYOR.
 - CP#1 (CROSS CUT) X=3,668,823.41 Y=535,617.41, EL= -1.13
 - CP#2 (CROSS CUT) X=3,668,696.78 Y=535,555.35, EL= -1.90
 - CP#3 (CROSS CUT) X=3,668,907.42 Y=535,969.14, EL= -7.89
 - TBM ('X' SET ON STEEL BRIDGE COLUMN) EL= +4.0

UNDERGROUND UTILITY INFORMATION:

ONE-CALL TICKET NUMBER 170382079 (8-18-17)

ENTERGY GAS NEW ORLEANS - SITE CLEAR, ABANDONED 20" L.P. GAS LINE

ENTERGY ELECTRIC NEW ORLEANS - SITE CLEAR

UNITY FIBER (FORMERLY HUNT / SOUTHERN LIGHT) - MARKED IN FIELD

AT&T - MARKED IN FIELD

LEVEL 3 COMMUNICATIONS - MARKED IN FIELD

MCI COMMUNICATION - NO CORRESPONDENCE FROM UTILITY OWNER

QWEST COMMUNICATION - MARKED IN FIELD

SUDDEN LINK COMMUNICATIONS - NO CORRESPONDENCE FROM UTILITY OWNER

NOTE:

FOR EXISTING CONDITIONS, SEE TOPOGRAPHIC SURVEY OF NEW CARROLLTON BY BATTURE ENGINEERS AND SURVEYORS LLC. DATED AUGUST 25, 2017.

NOTES:

LOCATION OF UNDERGROUND ELECTRIC CONDUIT FOR STREET LIGHTS WAS NOT PROVIDED BY ITS OWNER

FOR STREET LIGHTS WAS NOT PROVIDED BY ITS OWNER

LEGEND


★ - LIGHT POLE	⊙ - DRAIN MANHOLE	----- FO ----- - FIBER OPTIC LINE
- GUY WIRE	⊙ - SIGN, POLE MOUNTED	----- (SIZE) D ----- - DRAIN LINE
⊗ - POWER POLE	⊙ - SPOT ELEVATION	----- E ----- - UG ELECTRIC
⊗ - FIRE HYDRANT	⊙ - CATCH BASIN	----- (SIZE) S ----- - SEWER LINE
⊗ - WATER METER	⊕ - CROSS CUT	----- (SIZE) G ----- - GAS LINE
⊙ - SEWER MANHOLE	⊙ - ELECTRIC MANHOLE	----- (SIZE) W ----- - WATER LINE
⊙ - SEWER CLEANOUT	⊙ - TREE	----- ATT ----- - ATT LINE (UNDERGROUND)
⊙ - WATER MANHOLE	⊙ - PALM TREE	▨ - BUILDING
⊙ - COMMUNICATION BOX		
----- - NEW DUCT BANK AND FEEDER		

REFERENCE INFO ONLY

REFERENCE DWG.12144-W-27 SHT. # 13

SEWERAGE AND WATER BOARD OF NEW ORLEANS			
CONTRACT 5264			
OVERHAUL OF OLD CARROLLTON UNDERPASS PUMPING STATION			
UTILITY SITE PLAN			
DR. NFB	S-3		
TRC. XX	DWG. No. 12303-W-18		
CHK. TS			
AP. TS			
SCALE: AS NOTED			
DATE: 11/05/2025	SET NO.	SHEET NO. 3-OF-7	

TOPOGRAPHIC SURVEY OF SEWERAGE & WATER
UNDERPASS DRAINAGE PS (OLD & NEW CARROLLTON)
AND SURROUNDING AREA
CARROLLTON AT INTERSTATE 10
FIRST DISTRICT
CITY OF NEW ORLEANS

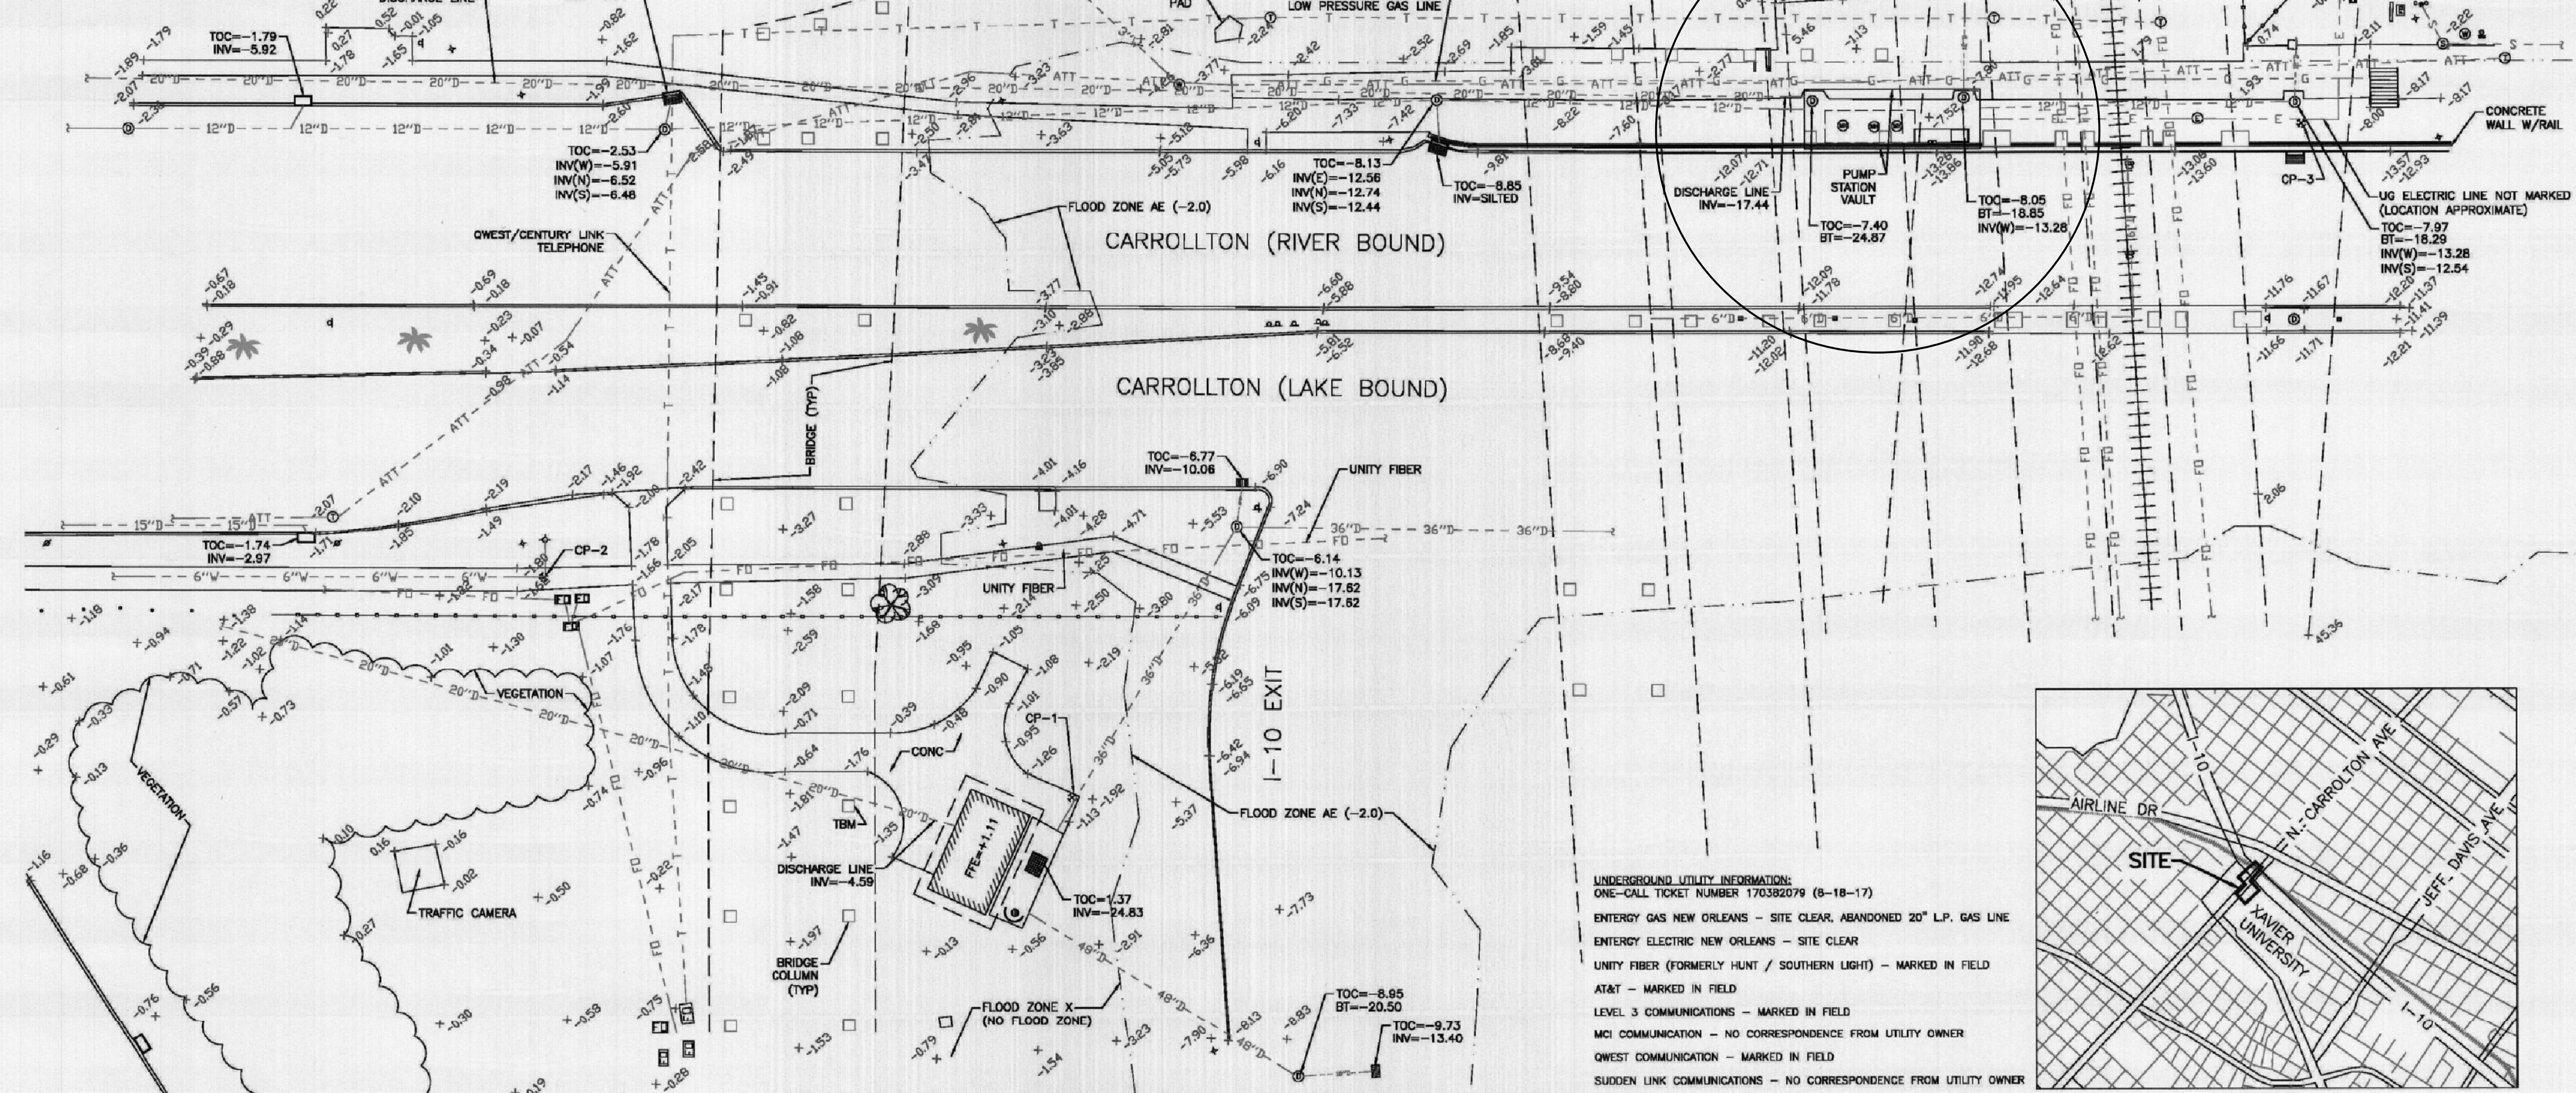


UNDERGROUND UTILITY INFORMATION:
ONE-CALL TICKET NUMBER 170382079 (8-18-17)
ENTERGY GAS NEW ORLEANS - SITE CLEAR, ABANDONED 20" L.P. GAS LINE
ENTERGY ELECTRIC NEW ORLEANS - SITE CLEAR
UNITY FIBER (FORMERLY HUNT / SOUTHERN LIGHT) - MARKED IN FIELD
AT&T - MARKED IN FIELD
LEVEL 3 COMMUNICATIONS - MARKED IN FIELD
MCI COMMUNICATION - NO CORRESPONDENCE FROM UTILITY OWNER
QWEST COMMUNICATION - MARKED IN FIELD
SUDDEN LINK COMMUNICATIONS - NO CORRESPONDENCE FROM UTILITY OWNER



- NOTES:
1. THE FOLLOWING DOES NOT REPRESENT A BOUNDARY SURVEY.
 2. THE LOCATIONS OF UNDERGROUND AND OTHER NONVISIBLE UTILITIES SHOWN HEREON HAVE BEEN PLOTTED BASED UPON DATA EITHER FURNISHED BY THE AGENCIES CONTROLLING SUCH DATA AND/OR OBTAINED FROM RECORDS MADE AVAILABLE TO US BY THE AGENCIES CONTROLLING SUCH RECORDS. WHERE FOUND, THE SURFACE FEATURES OF UTILITIES ARE SHOWN. THE ACTUAL NONVISIBLE LOCATIONS MAY VARY FROM THOSE SHOWN HEREON. EACH AGENCY SHOULD BE CONTACTED RELATIVE TO THE PRECISE LOCATION OF ITS UNDERGROUND INSTALLATIONS PRIOR TO ANY RELIANCE UPON THE ACCURACY OF SUCH LOCATIONS SHOWN HEREON. PRIOR TO EXCAVATION AND DIGGING CALL I.A. ONE CALL (1-800-272-3020).
 3. AS PER FLOOD INSURANCE RATE MAP NUMBER 220710228F, EFFECTIVE DATE SEPTEMBER 30, 2016, THE SITE IS IN ZONE X (NOT FLOOD ZONE) AND AE (EL. -2.0).
 4. ELEVATIONS AND BEARINGS SHOWN REFER BASED ON GPS MEASUREMENTS, LSU GULF NET, NAD 83, NORTH AMERICAN DATUM (1983) LAMBERT CONFORMAL CONIC PROJECTION, LOUISIANA SOUTH ZONE, STATE PLANE COORDINATE SYSTEM, US SURVEY FEET, NAVD83.
 5. NO TITLE RESEARCH OR UTILITY SERVICE RESEARCH WAS PERFORMED BY THE SURVEYOR.
 6. CP#1 (CROSS CUT) X=3,668,923.41 Y=535,617.41, EL= -1.13
 7. CP#2 (CROSS CUT) X=3,668,698.78 Y=535,555.35, EL= -1.90
 8. CP#3 (CROSS CUT) X=3,668,907.42 Y=535,969.14, EL= -7.89
 9. TBM (7' SET ON STEEL BRIDGE COLUMN) EL= +4.0

LEGEND	
⋆ - LIGHT POLE	⊕ - DRAIN MANHOLE
- - - GUY WIRE	⊖ - SIGN, POLE MOUNTED
⊕ - POWER POLE	⊖ - SPOT ELEVATION
⊖ - FIRE HYDRANT	⊖ - CATCH BASIN
⊖ - WATER METER	⊖ - CROSS CUT
⊖ - SEWER MANHOLE	⊖ - ELECTRIC MANHOLE
⊖ - SEWER CLEANOUT	⊖ - TREE
⊖ - WATER MANHOLE	⊖ - PALM TREE
⊖ - COMMUNICATION BOX	

PREPARED FOR CH2M HILL
ENGINEERS, INC.
I HEREBY CERTIFY THIS PLAT
REPRESENTS AN ACTUAL GROUND
SURVEY MADE BY ME OR UNDER
MY DIRECT SUPERVISION AND
CONTROL.


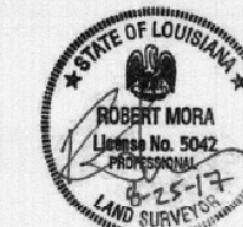


ROBERT MORA PE, PLS
PLS #5042
AUGUST 25, 2017
(504) 261-7143

BATTURE LLC
engineers + land surveyors
500 CRYSTAL ST, NEW ORLEANS, LA 70124
PH 504-261-7143
FAX 504-336-2272
BMORA@BATTURE-ENG.COM

REFERENCE INFO ONLY

REV.	DATE	DESCRIPTION	BY
SEWERAGE AND WATER BOARD OF NEW ORLEANS			
CONTRACT 5264 OVERHAUL OF OLD CARROLLTON UNDERPASS PUMPING STATION			
SURVEY			
DR.	NFB	S-4	
TRC.	XX	DWG. No. 12303-W-18	
CK.	TS	SCALE: AS NOTED	
AP.	TS	DATE: 11/05/2025	
SET NO.		SHEET NO. 4-OF-7	

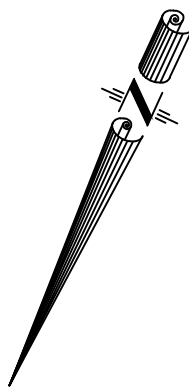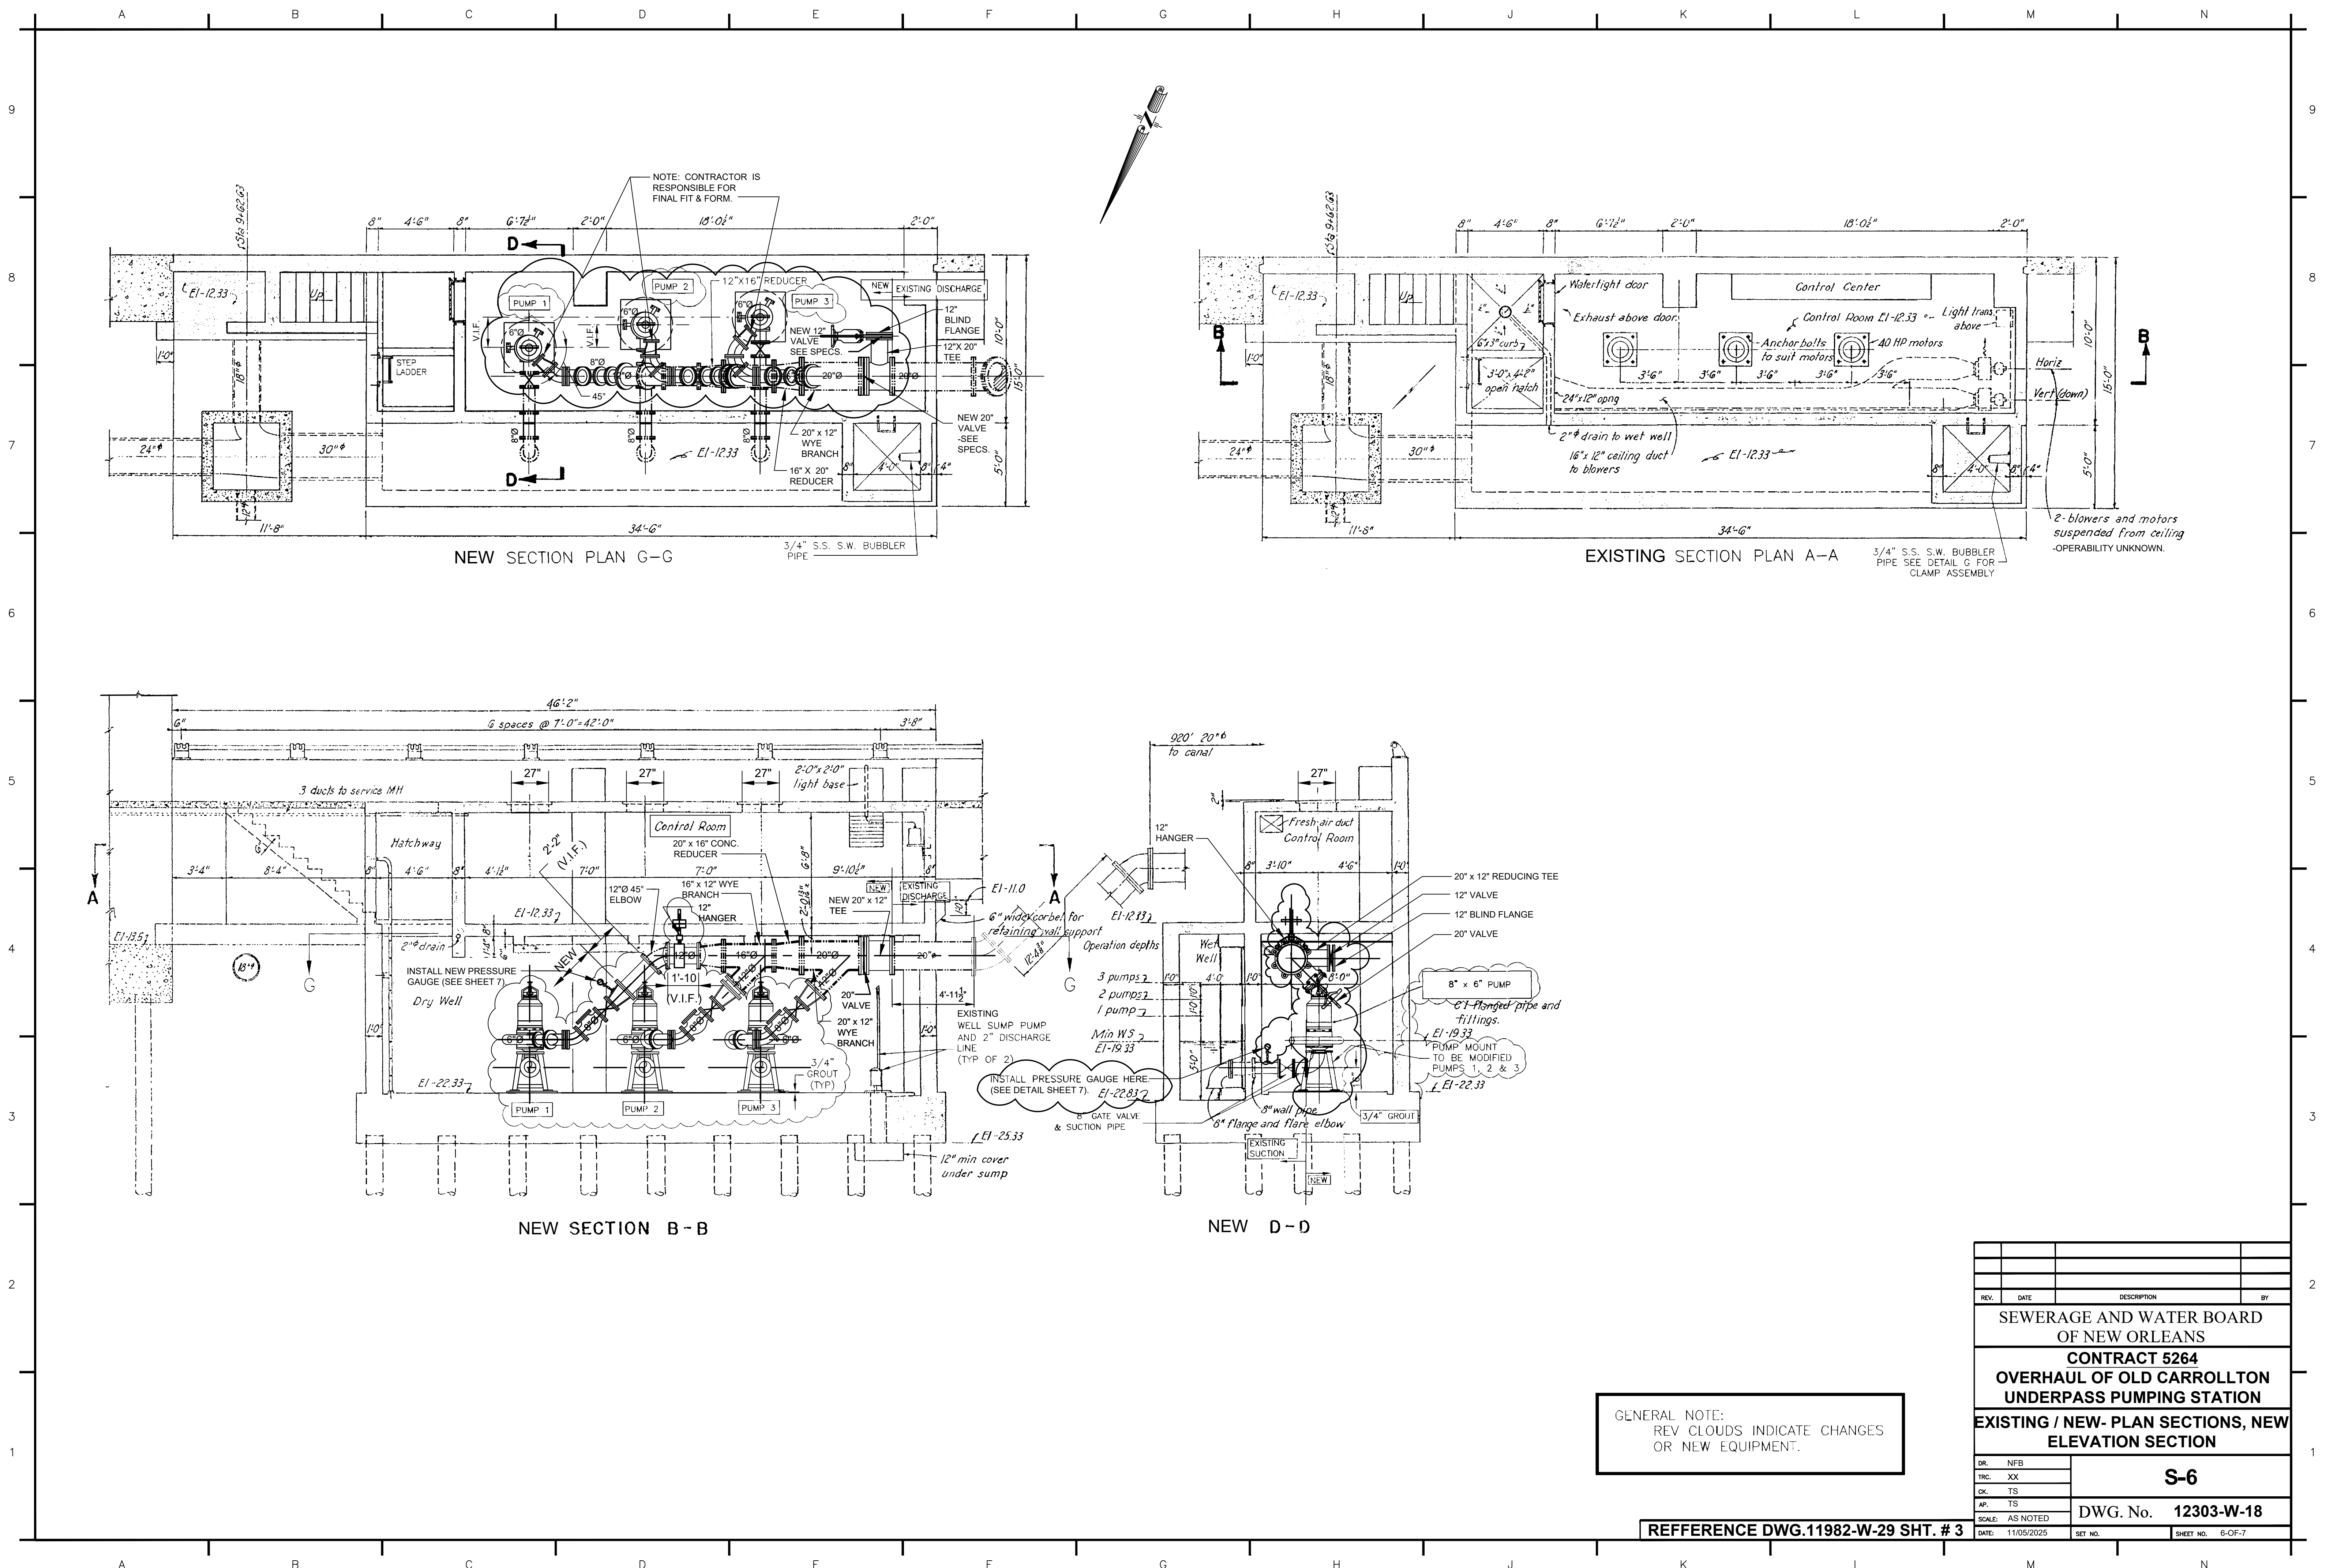


GENERAL NOTE:
REV CLOUDS INDICATE CHANGES
OR NEW EQUIPMENT.

REV.	DATE	DESCRIPTION	BY
SEWERAGE AND WATER BOARD OF NEW ORLEANS			
CONTRACT 5264			
OVERHAUL OF OLD CARROLLTON UNDERPASS PUMPING STATION			
EXISTING / NEW- PLAN SECTIONS, NEW ELEVATION SECTION			
DR.	NFB	S-6	
TRC.	XX		
CHK.	TS		
APP.	TS		
SCALE:	AS NOTED	DWG. No. 12303-W-18	
DATE:	11/05/2025	SCH. NO.	SHEET NO. 6-OF-7


REFERENCE DWG.11982-W-29 SHT. # 3

A B C D E F G H J K L M N



9
8
7
6
5
4
3
2
1

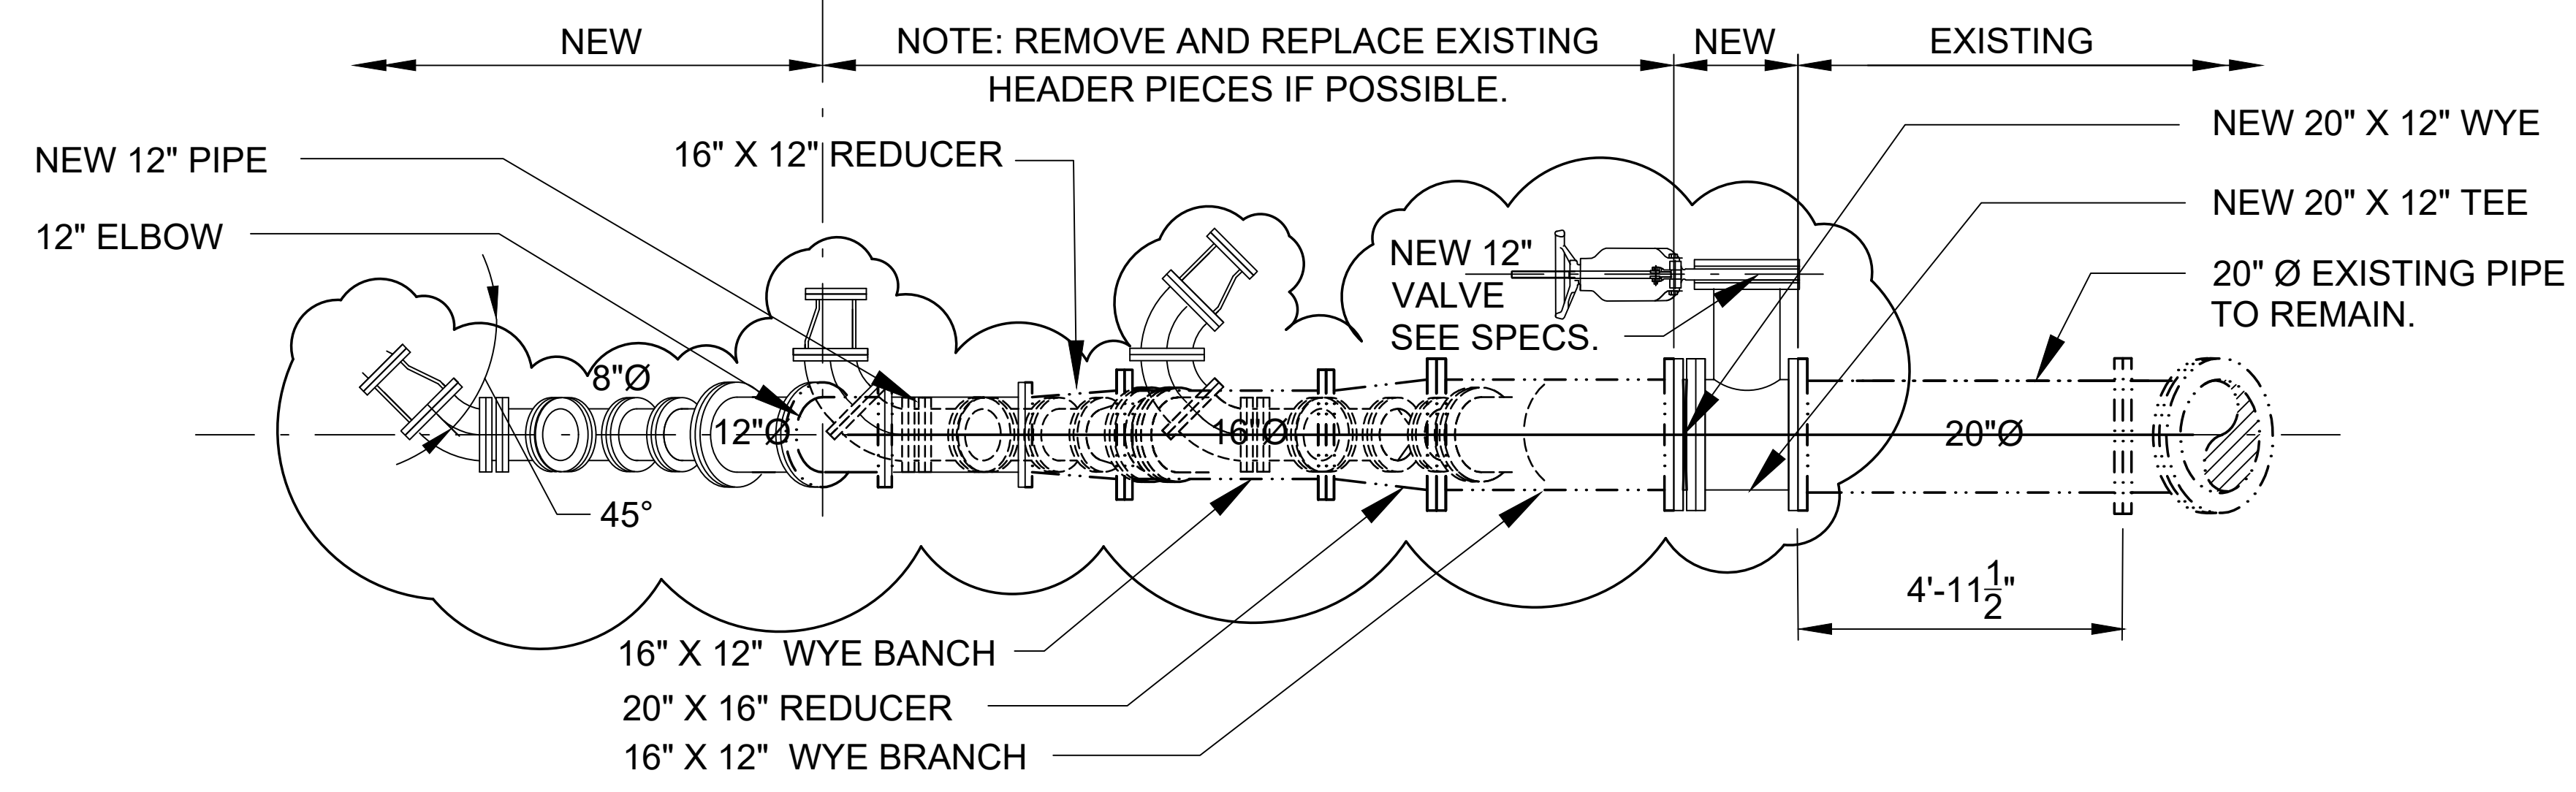

NEW PLAN VIEW HEADER

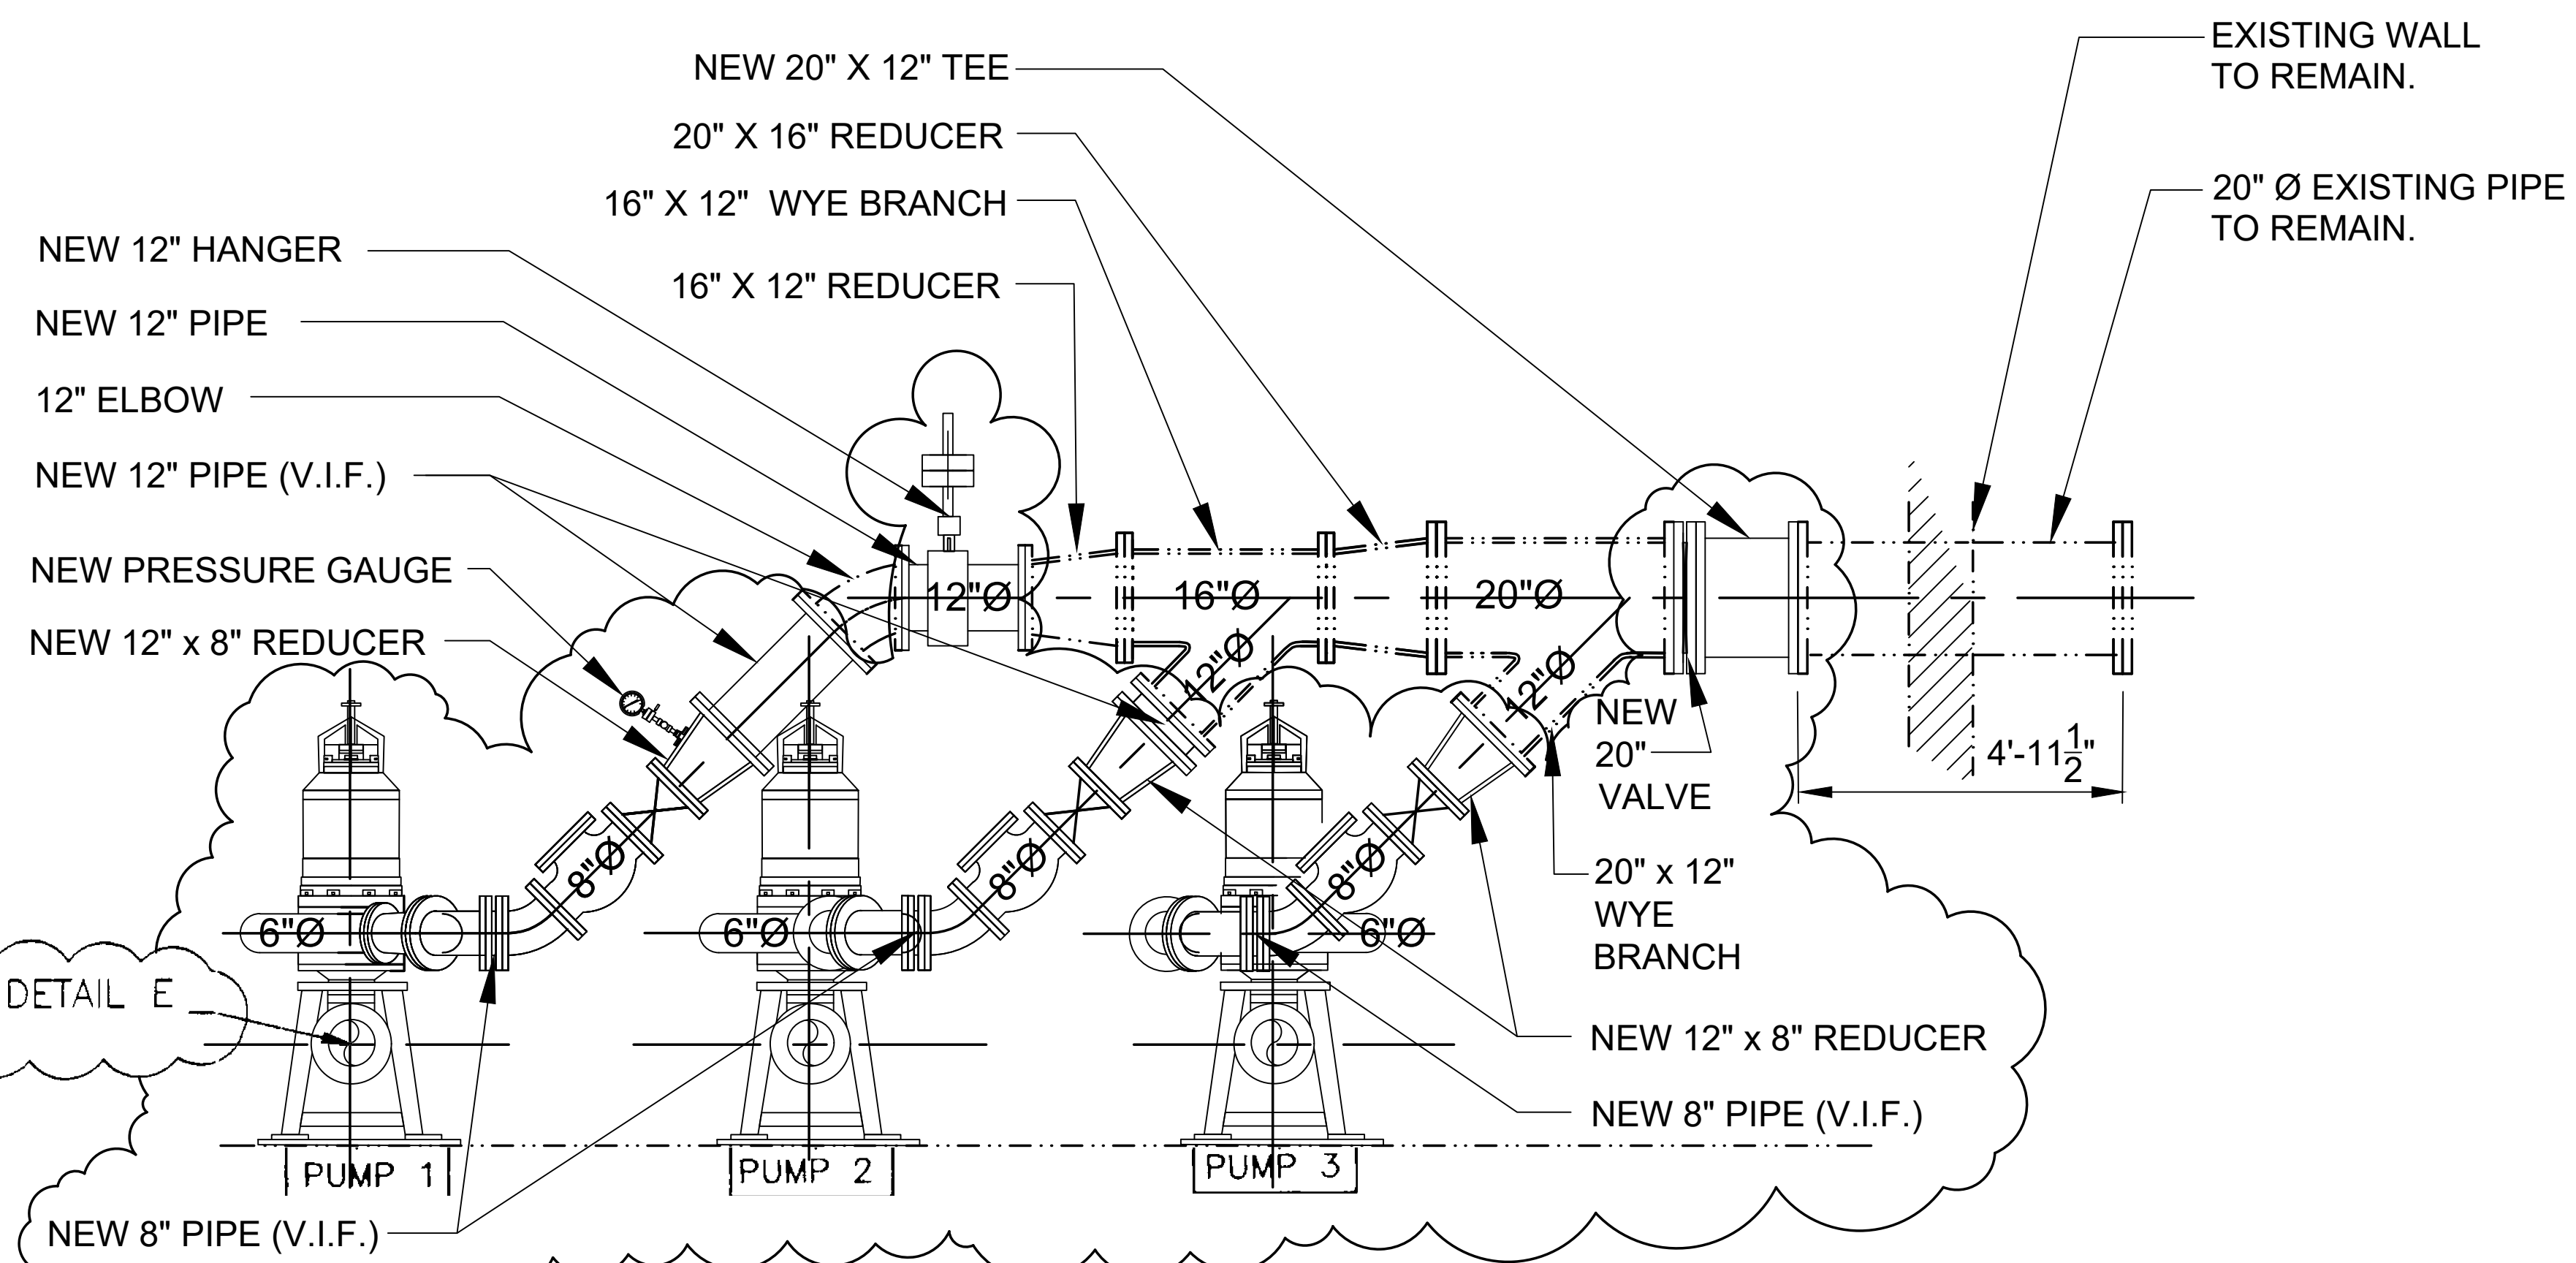

NEW ELEVATION HEADER

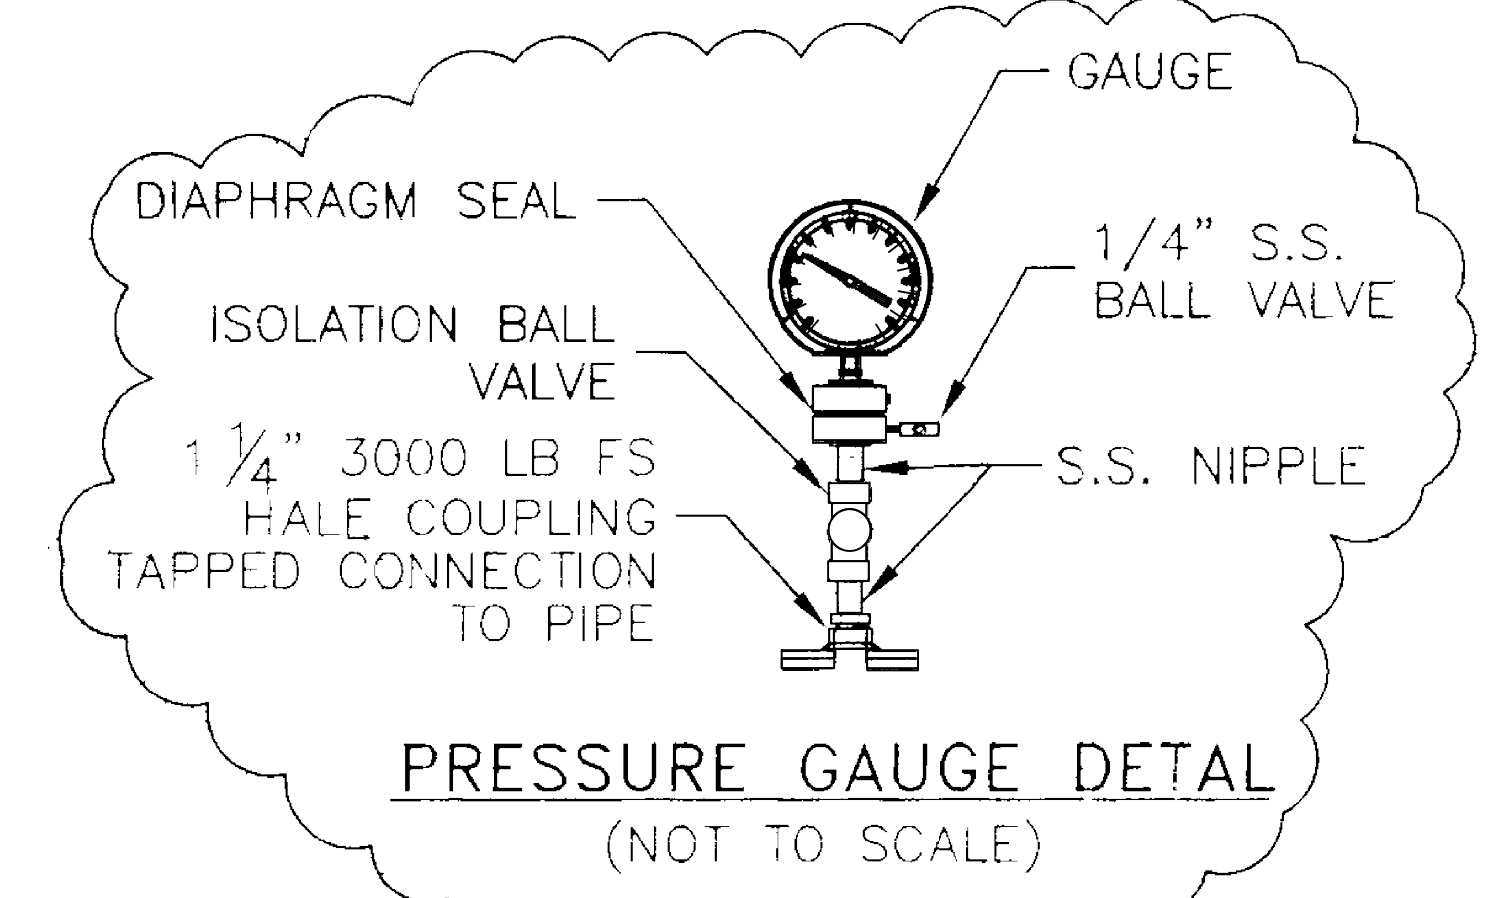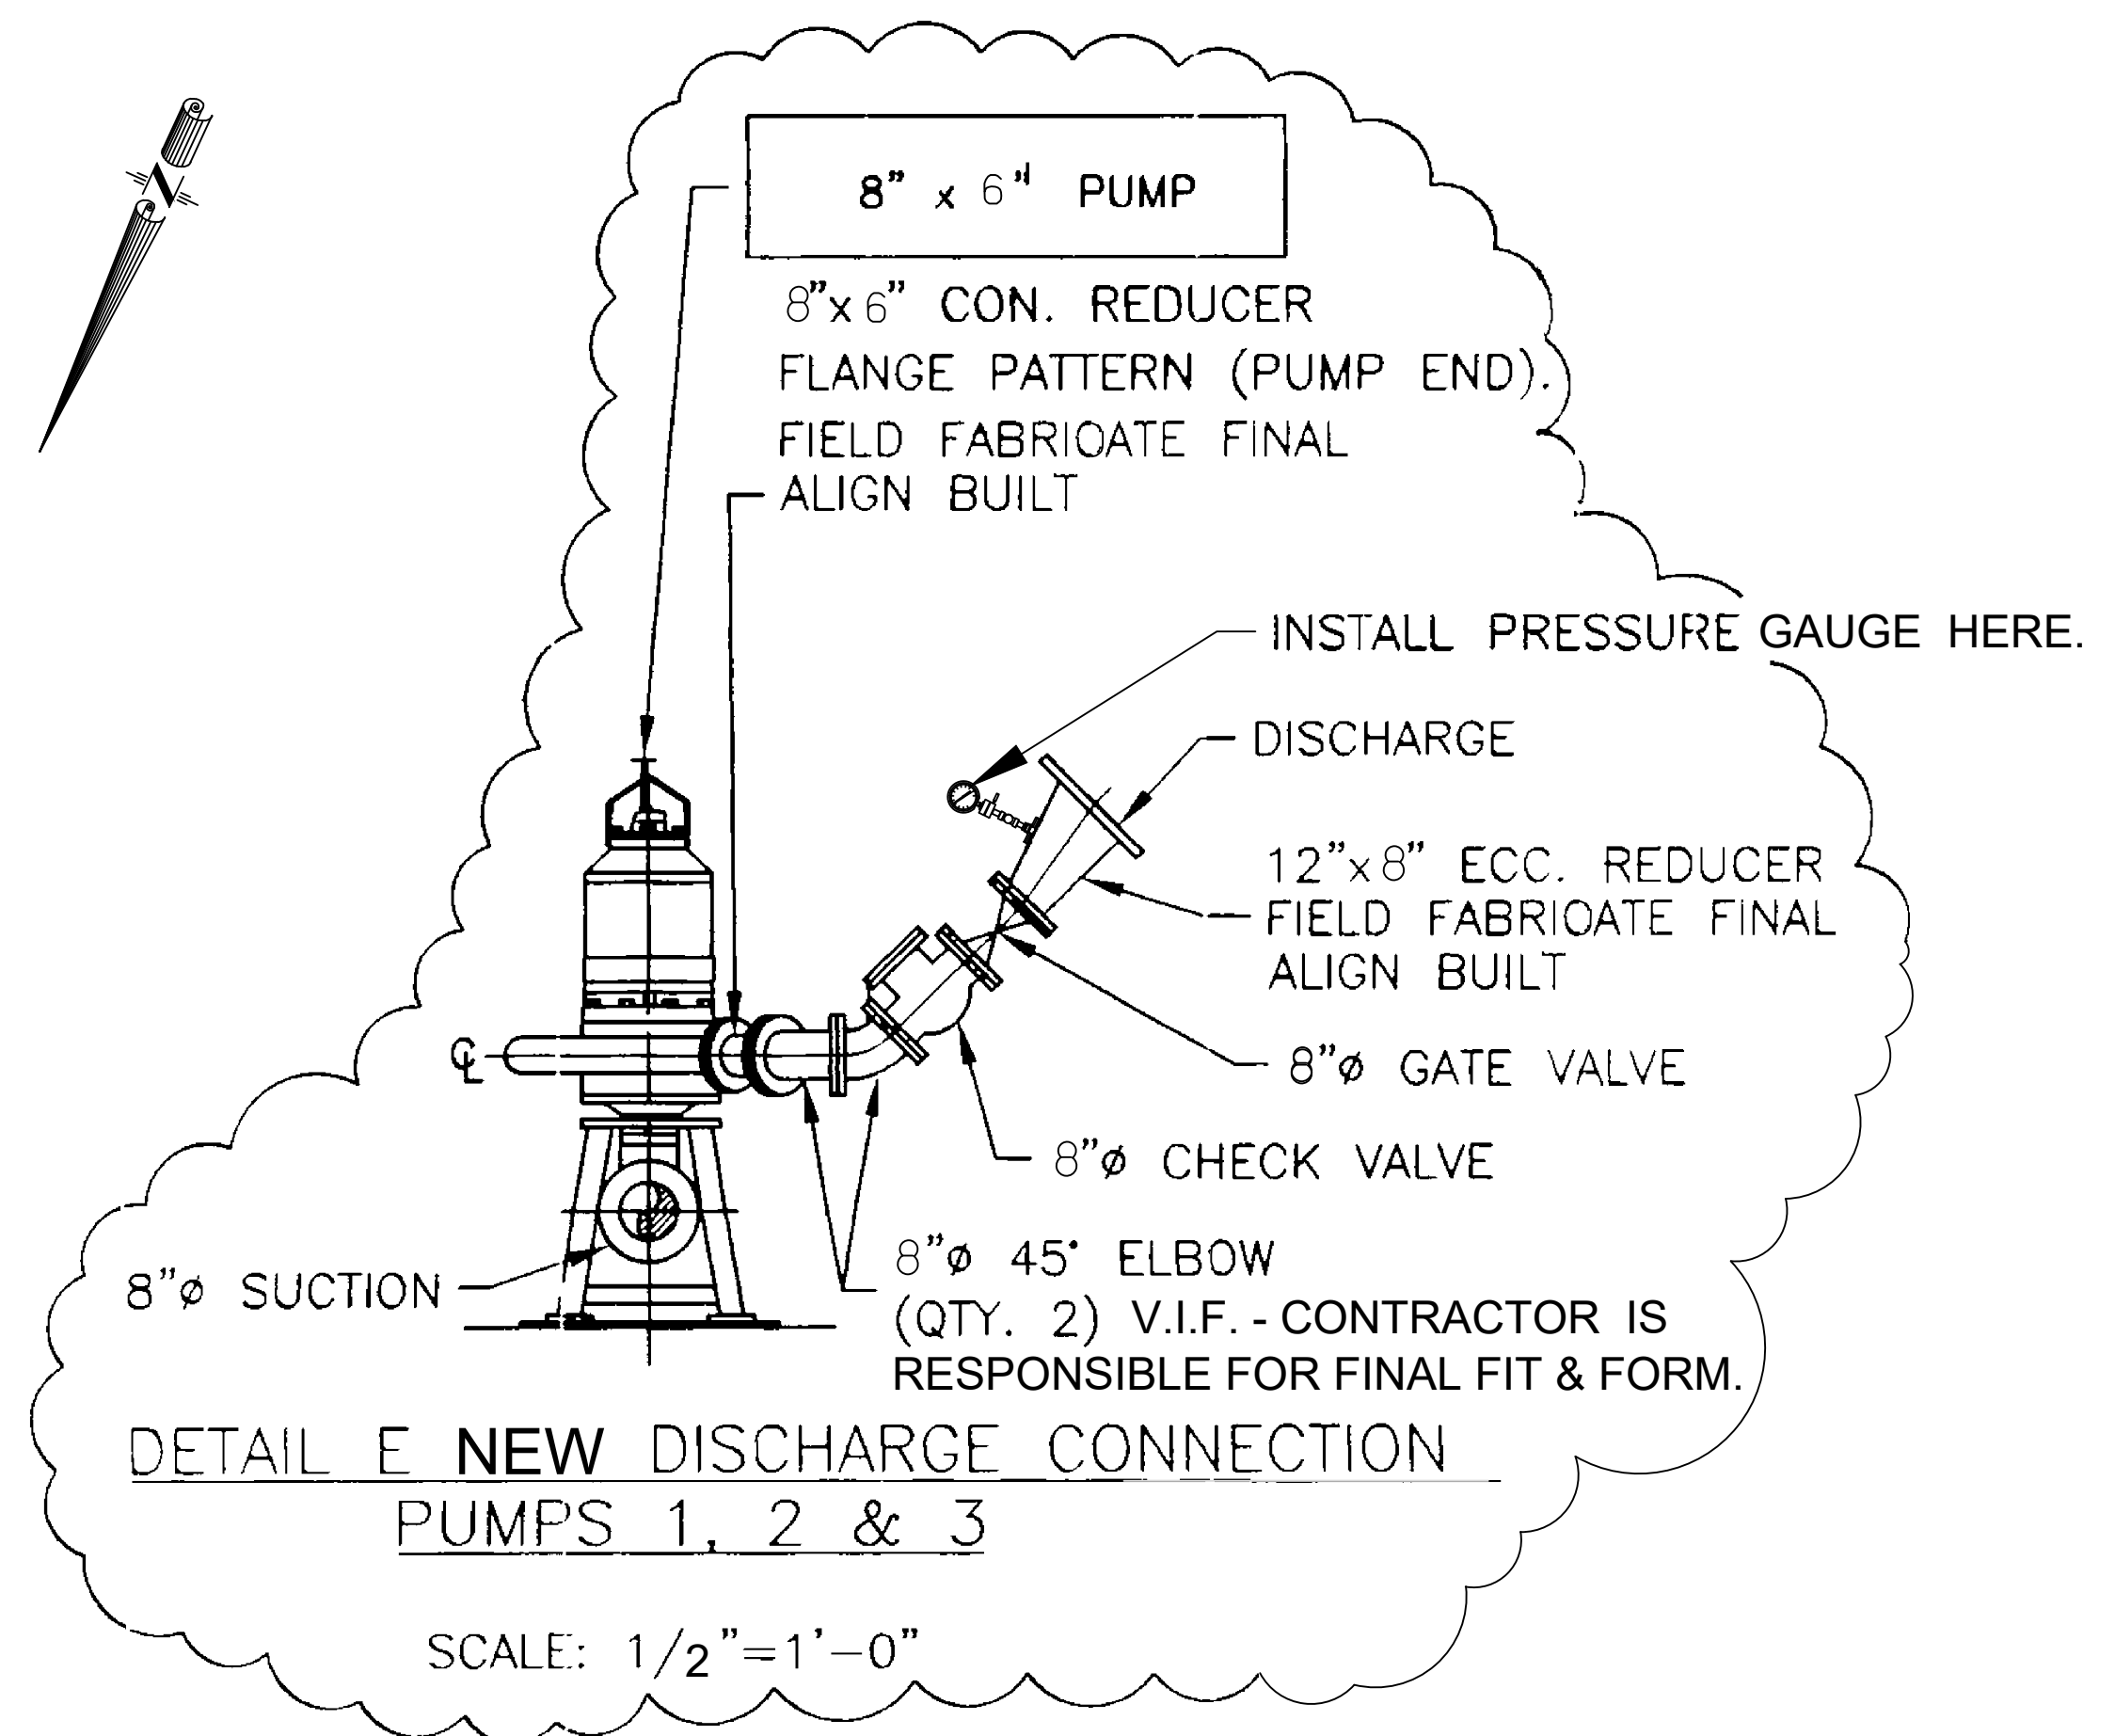

GENERAL NOTE:
REV CLOUDS INDICATE CHANGES
OR NEW EQUIPMENT.

REV.	DATE	DESCRIPTION	BY
SEWERAGE AND WATER BOARD OF NEW ORLEANS			
CONTRACT 5264 OVERHAUL OF OLD CARROLLTON UNDERPASS PUMPING STATION			
NEW- PLAN SECTION, NEW ELEVATION SECTION & DETAILS			
DR.	NFB	S-7	
TRC.	XX	DWG. No. 12303-W-18	
CHK.	TS	DATE: 11/05/2025	
APP.	TS	SHEET NO. 7-OF-7	
SCALE:	AS NOTED	REFERENCE DWG.11982-W-29 SHT. # 3	