



DWG: R:\2014\141399 - Jackson Barracks Electrical Distribution Study\Cad\Production_Plans\86121G-3 (Site Plan) dwg
 DATE: Sep 03, 2016 7:12am XREFS:\RIMNEW\3624 86121\SITE 86121\SETUP 86121\ASV 141399E_Pleascope Earth Aerial
 USER: c:\p\141399E_Pleascope Earth Aerial 141399E_Pleascope Earth Aerial-1

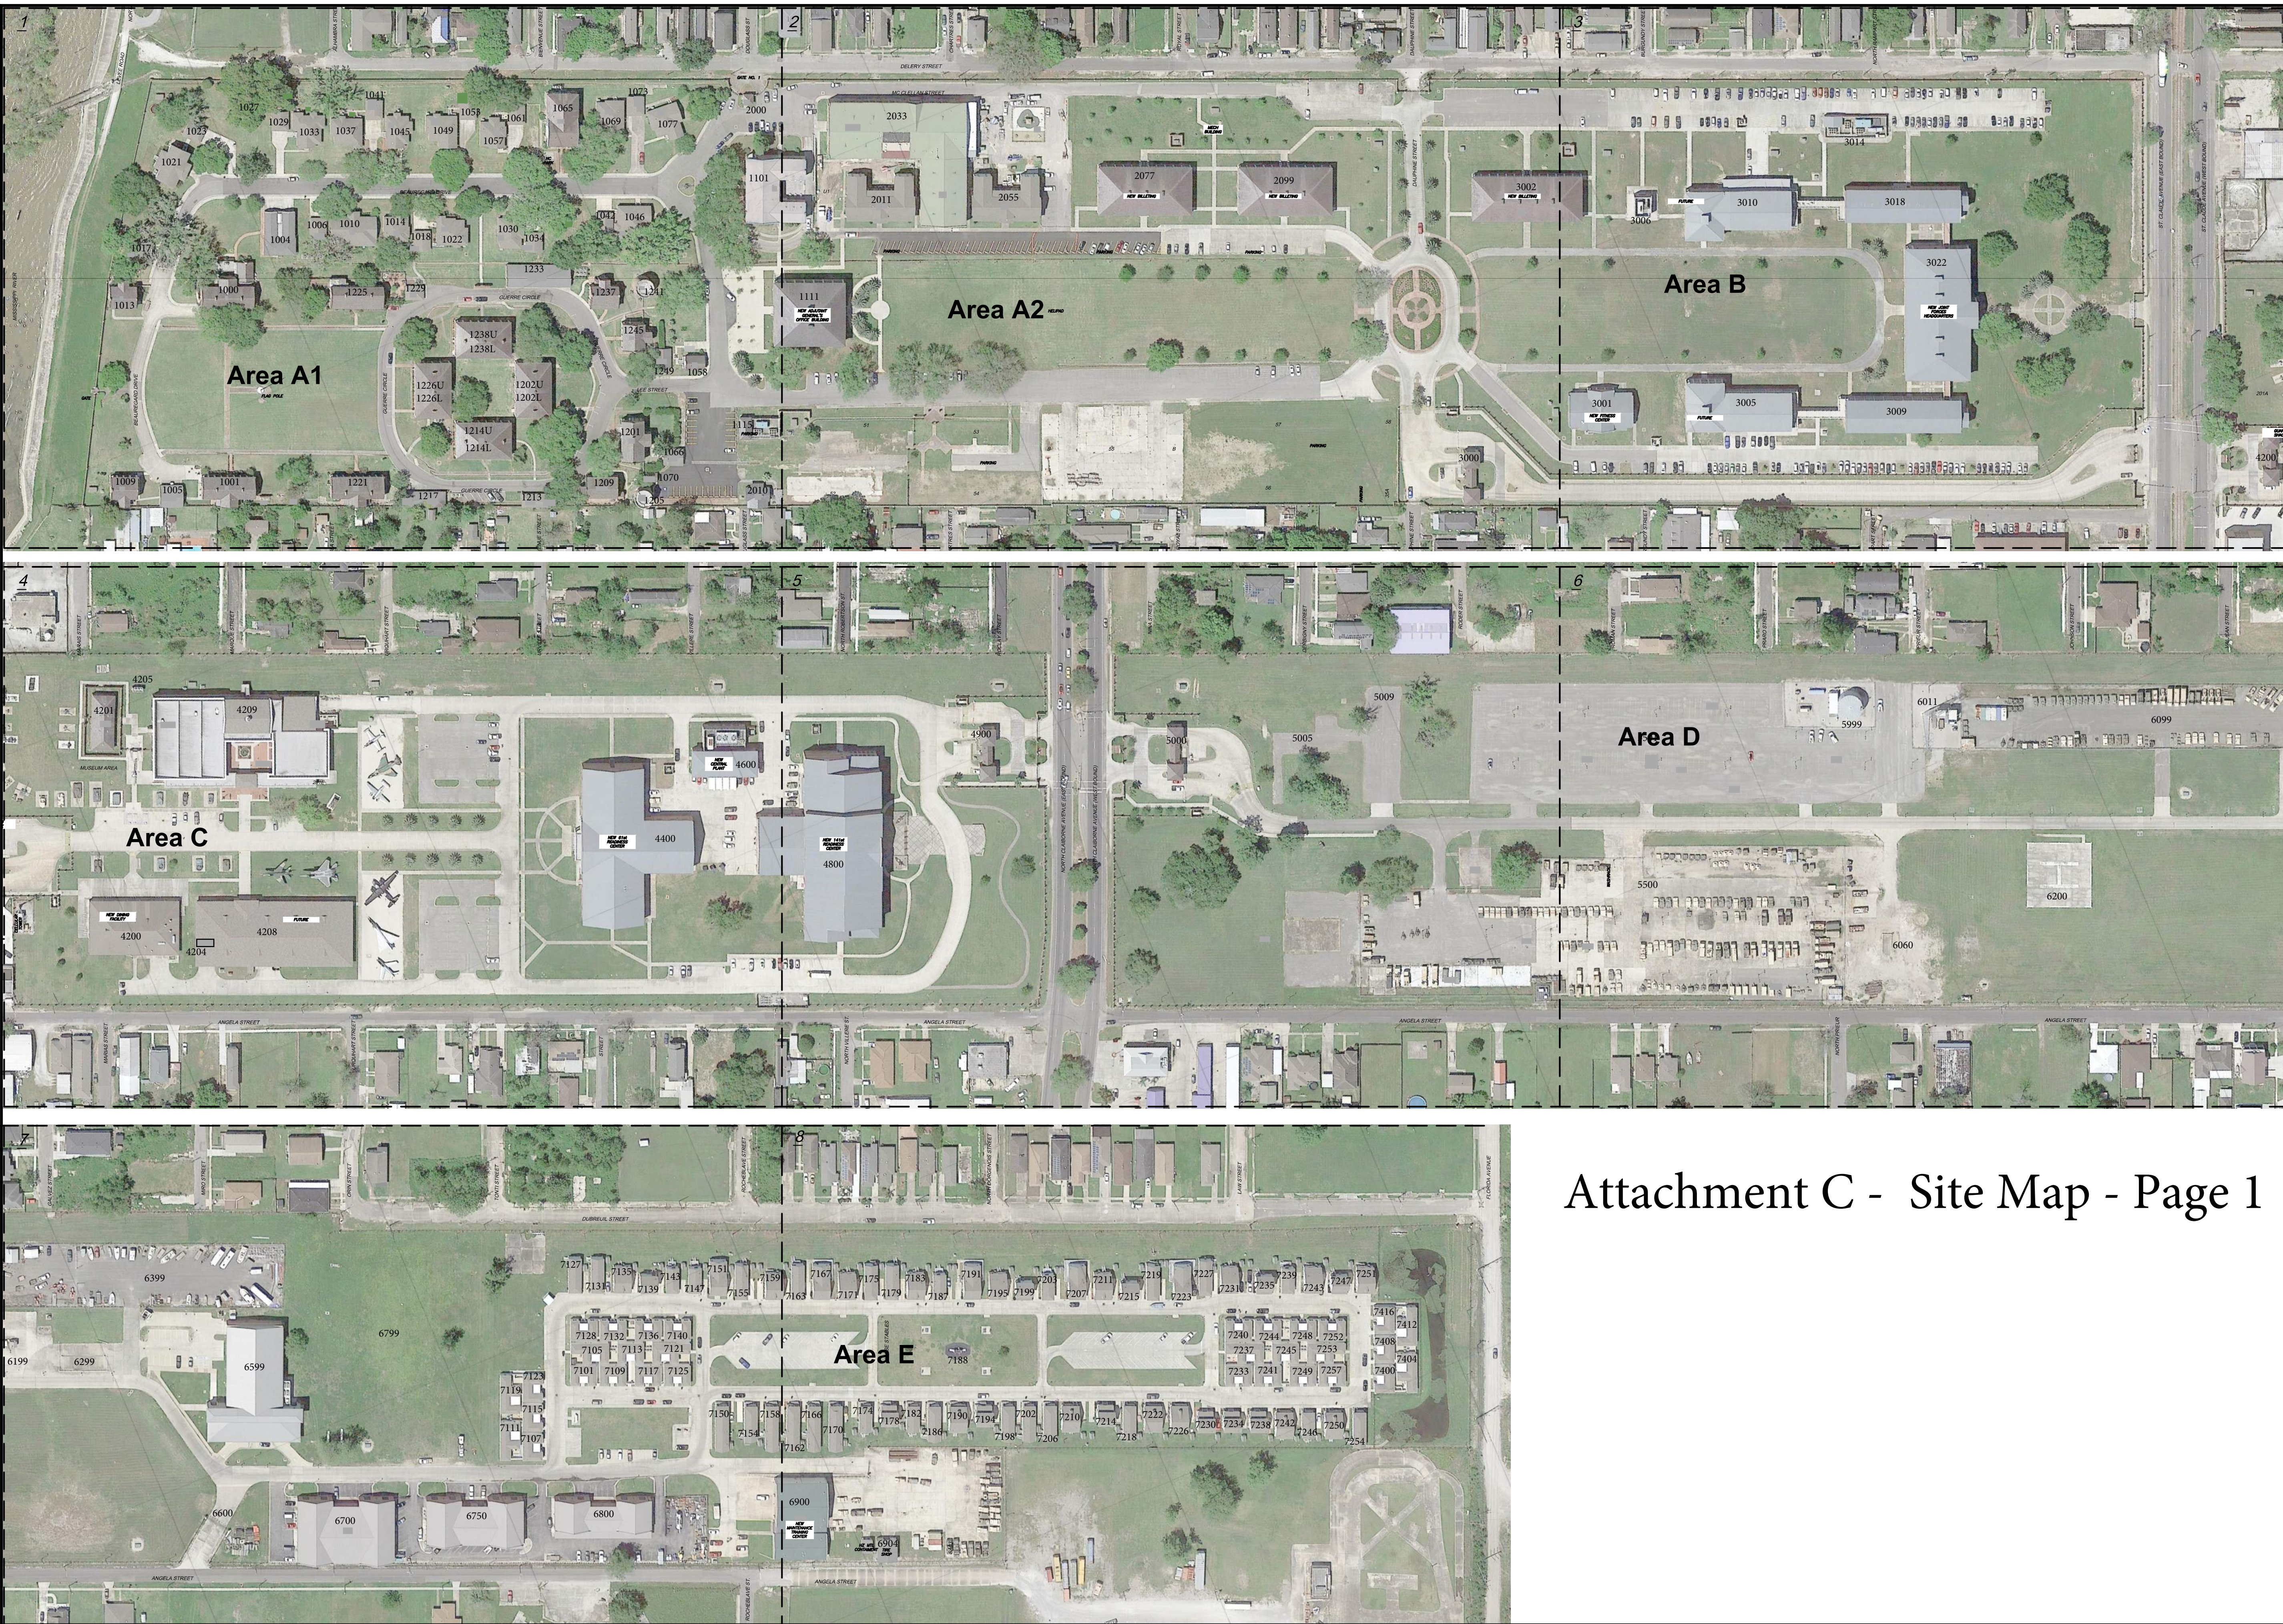

1	SHEET INDEX
C0.1	AREA A - EXISTING SITE SURVEY
C1.1	SANITARY SYSTEM PLAN
C2.1	WATER SYSTEM PLAN
C4.1	STORM DRAINAGE PLAN
C5.1	ROADWAY PLAN
E1.1	ELECTRICAL UG DUCTBANK SYSTEM PLAN
E2.1	DATA & COM. UG DUCTBANK SYSTEM PLAN
E3.1	LIGHTING SYSTEM PLAN
2	SHEET INDEX
C0.2	AREAS A & B - EXISTING SITE SURVEY
C1.2	SANITARY SYSTEM PLAN
C2.2	WATER SYSTEM PLAN
C4.2	STORM DRAINAGE PLAN
C5.2	ROADWAY PLAN
E1.2	ELECTRICAL UG DUCTBANK SYSTEM PLAN
E2.2	DATA & COM. UG DUCTBANK SYSTEM PLAN
E3.2	LIGHTING SYSTEM PLAN
3	SHEET INDEX
C0.3	AREAS B & C - EXISTING SITE SURVEY
C1.3	SANITARY SYSTEM PLAN
C2.3	WATER SYSTEM PLAN
C4.3	STORM DRAINAGE PLAN
C5.3	ROADWAY PLAN
E1.3	ELECTRICAL UG DUCTBANK SYSTEM PLAN
E2.3	DATA & COM. UG DUCTBANK SYSTEM PLAN
E3.3	LIGHTING SYSTEM PLAN
4	SHEET INDEX
C0.4	AREA C - EXISTING SITE SURVEY
C1.4	SANITARY SYSTEM PLAN
C2.4	WATER SYSTEM PLAN
C4.4	STORM DRAINAGE PLAN
C5.4	ROADWAY PLAN
E1.4	ELECTRICAL UG DUCTBANK SYSTEM PLAN
E2.4	DATA & COM. UG DUCTBANK SYSTEM PLAN
E3.4	LIGHTING SYSTEM PLAN
5	SHEET INDEX
C0.5	AREAS C & D - EXISTING SITE SURVEY
C1.5	SANITARY SYSTEM PLAN
C2.5	WATER SYSTEM PLAN
C4.5	STORM DRAINAGE PLAN
C5.5	ROADWAY PLAN
E1.5	ELECTRICAL UG DUCTBANK SYSTEM PLAN
E2.5	DATA & COM. UG DUCTBANK SYSTEM PLAN
E3.5	LIGHTING SYSTEM PLAN
6	SHEET INDEX
C0.6	AREA D - EXISTING SITE SURVEY
C1.6	SANITARY SYSTEM PLAN
C2.6	WATER SYSTEM PLAN
C4.6	STORM DRAINAGE PLAN
C5.6	ROADWAY PLAN
E1.6	ELECTRICAL UG DUCTBANK SYSTEM PLAN
E2.6	DATA & COM. UG DUCTBANK SYSTEM PLAN
E3.6	LIGHTING SYSTEM PLAN
7	SHEET INDEX
C0.7	AREAS D & E - EXISTING SITE SURVEY
C1.7	SANITARY SYSTEM PLAN
C2.7	WATER SYSTEM PLAN
C4.7	STORM DRAINAGE PLAN
C5.7	ROADWAY PLAN
E1.7	ELECTRICAL UG DUCTBANK SYSTEM PLAN
E2.7	DATA & COM. UG DUCTBANK SYSTEM PLAN
E3.7	LIGHTING SYSTEM PLAN
8	SHEET INDEX
C0.8	EXISTING SITE SURVEY
C1.8	SANITARY SYSTEM PLAN
C2.8	PROPOSED WATER LINES
C4.8	STORM DRAINAGE PLAN
C5.8	ROADWAY PLAN
E1.8	ELECTRICAL UG DUCTBANK SYSTEM PLAN
E2.8	DATA & COM. UG DUCTBANK SYSTEM PLAN
E3.8	LIGHTING SYSTEM PLAN

Attachment C - Site Map - Page 1

REFERENCE DWG.	DESCRIPTION	NO.	DATE	BY	REVISIONS	CK.	APP.


FORTE and TABLADA, INC.
 CONSULTING ENGINEERS
 9107 INTERLINE AVE.
 BATON ROUGE, LOUISIANA 70809
 PROJECT NUMBER

JACKSON BARRACKS INFRASTRUCTURE OVERALL SITE PLAN & SHEET INDEX

DESIGNED:	SCALE: 1"=120'
DRAWN:	PROJ. NO.
CHECKED:	SHEET: OF:
APPROVED:	DATE: JUNE 19, 2006
DRAWING NO.	REV.
G3	

86121G-3 (Site Plan)